




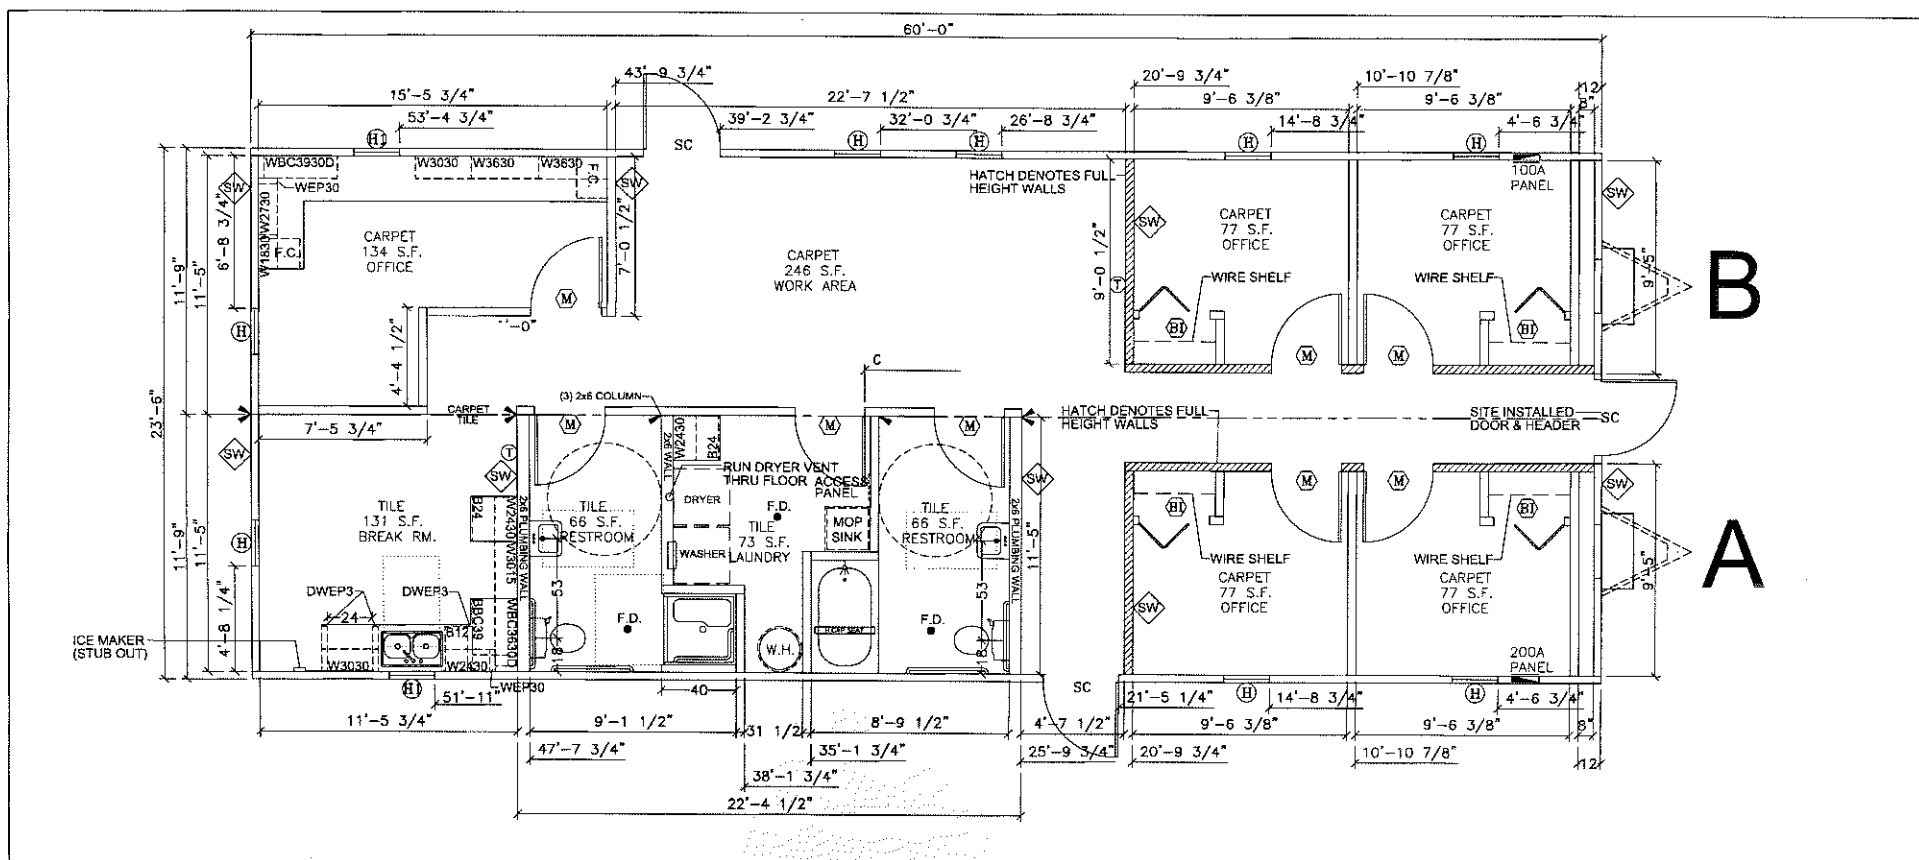


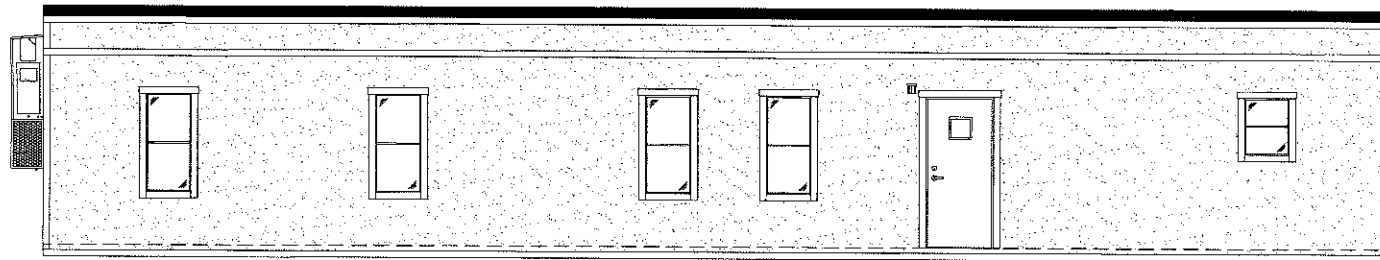


CURB SIDE

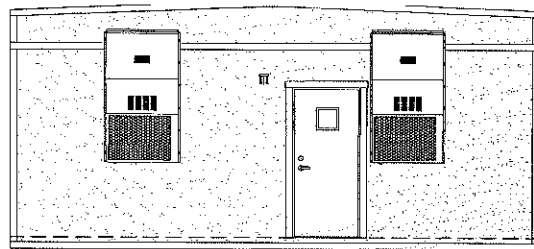

FRONT END

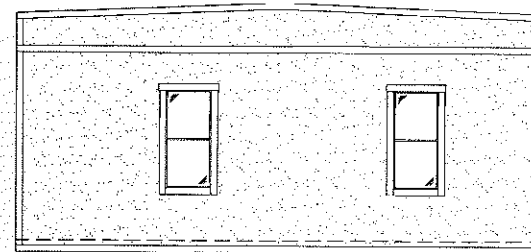


REAR END

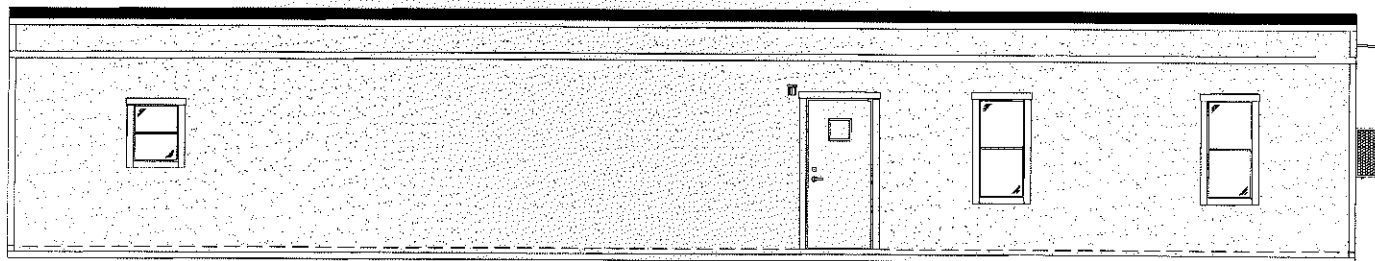


STREET SIDE

LTR	REVISION	BY	DATE	DRAWN BY:	PROJECT:	TITLE:	DWG. NO.	SHEET
						EXTERIOR ELEVATION		
				DATE:	SCALE:			
					3/16"=1'-0"		V2464-3	A-4

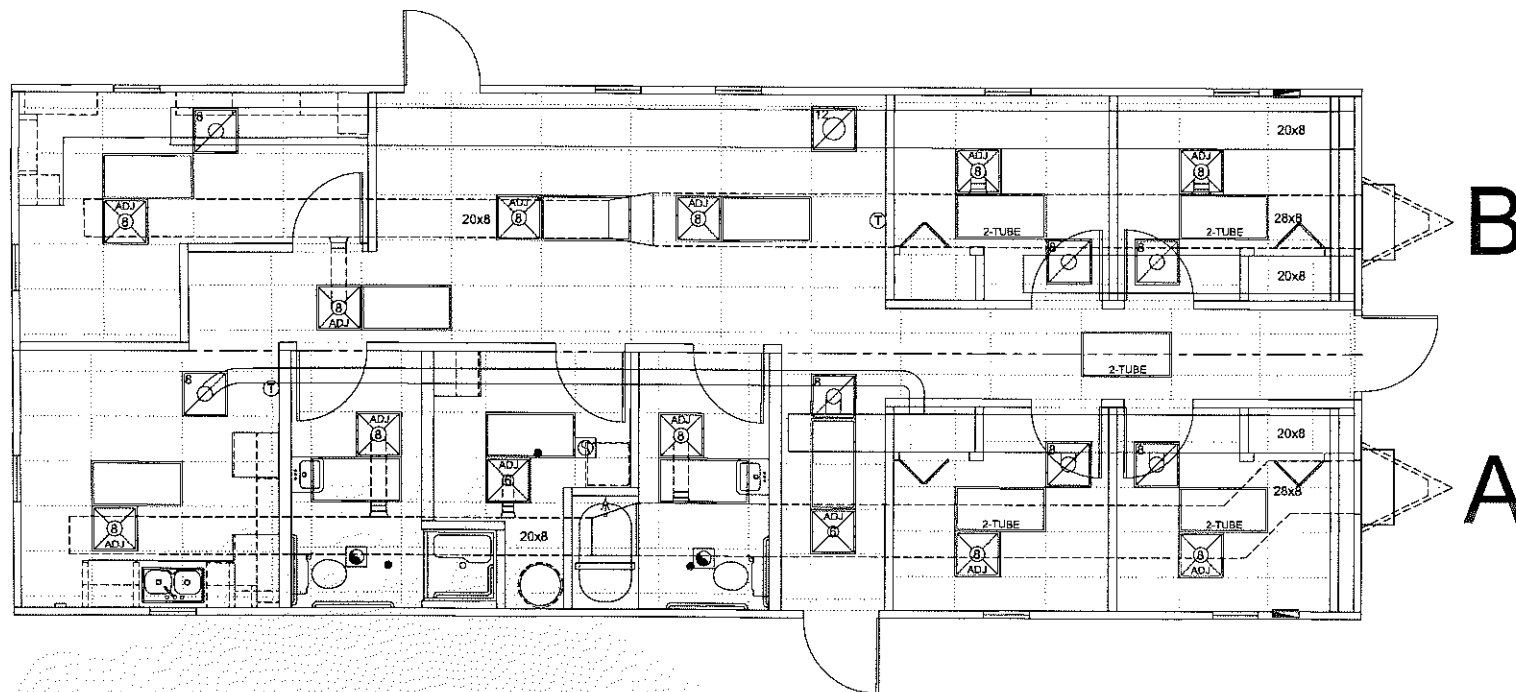


SYMBOL LEGEND

LTR	REVISION	BY	DATE	DRAWN BY:	PROJECT:	TITLE:
						CEILING & HVAC LAYOUT
				DATE:	SCALE:	DWG. NO.
					3/16"=1'-0"	V2464-3

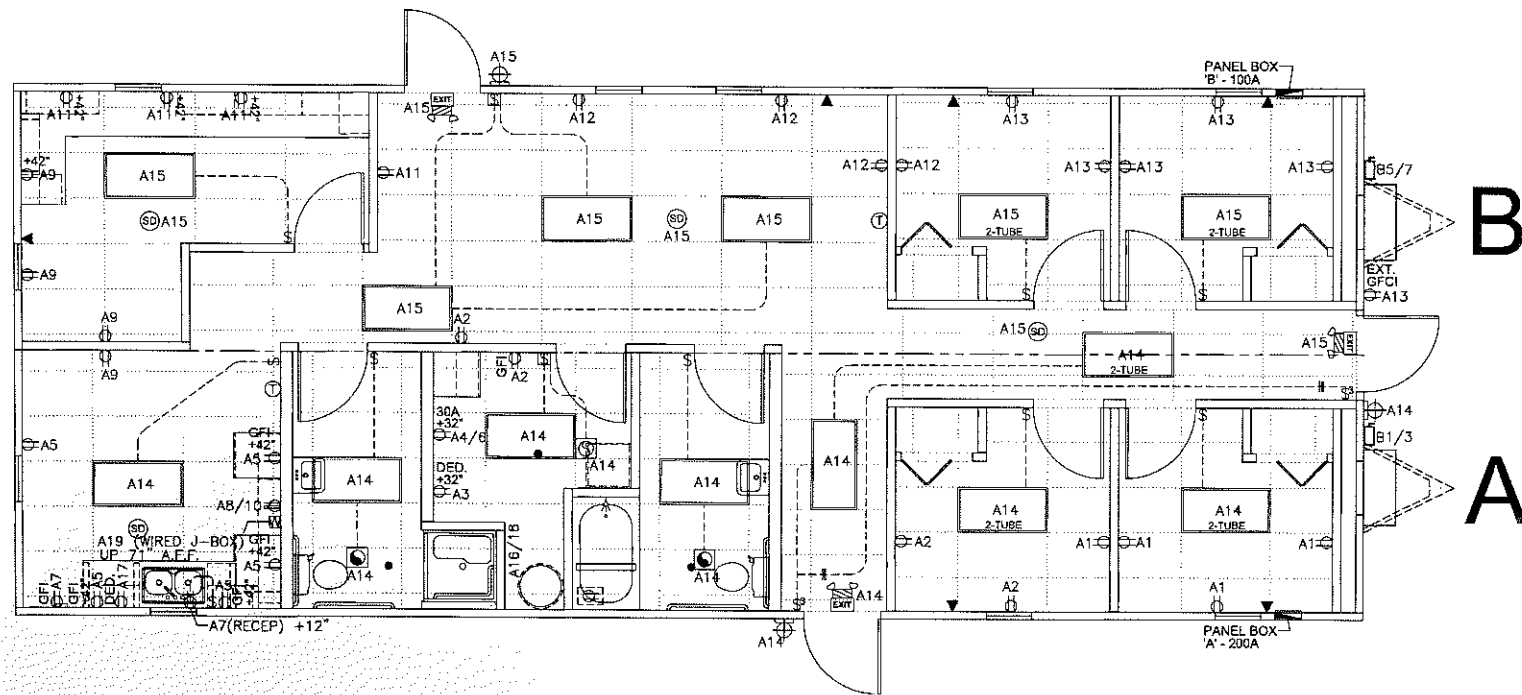

SYMBOL LEGEND

 

2'x4' T-8 4 TUBE TROFFER
W/ DIFFUSED LENS
(122 WATTS)



80CFM EXHAUST FAN ONLY



180CFM EXHAUST FAN ONLY



EXT. PORCH LIGHT W/ PHOTO CELL
(1.3 WATTS)



PHONE / DATA JACK STUB-IN LCTN



120V DOUBLE TOGGLE SWITCH



120V SINGLE TOGGLE SWITCH



120V DUPLEX RECEPTACLE



240V RANGE RECEPTACLE



200 AMP LOAD CENTER



EXT. DISCONNECT



THERMOSTAT LOCATION
(+48)



SURFACE MTD. SMOKE
DETECTOR (D/C)




EMER./EXIT W/ BATT. BACKUP

LTR	REVISION	BY	DATE	DRAWN BY

PROJECT:
SCALE:

TITLE:
DWG. NO.

17A

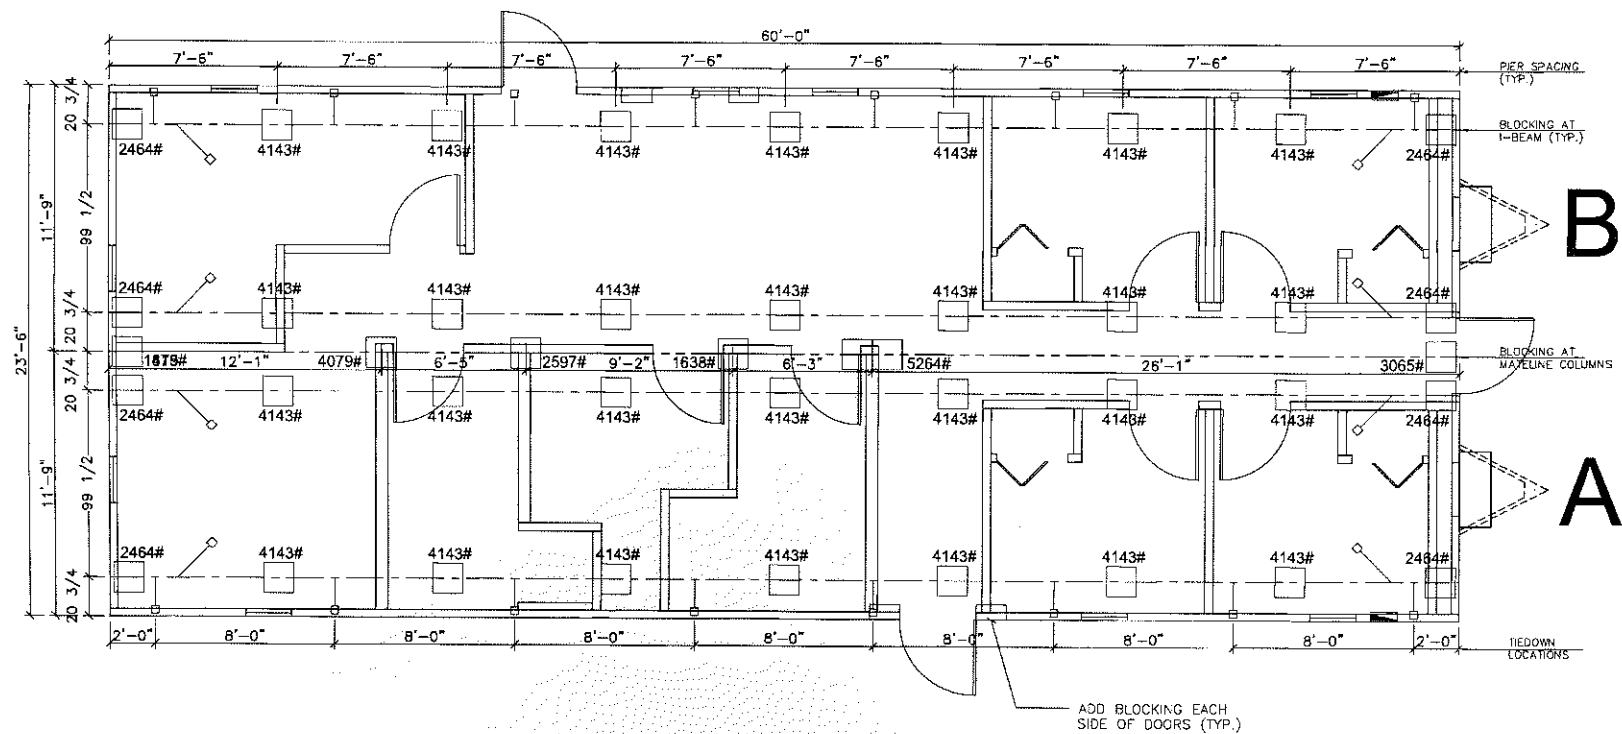

NOTES:

1. SOIL CAPACITY IS ASSUMED TO BE 2500 PSF (FIELD VERIFY BY OTHERS).
2. PIER SPACING BASED ON ASSUMED PAD SIZE OF 16" X 16".
3. BLOCKS ADDED EACH SIDE OF EXT. DOORS (TYP.)
4. PERMANENT FOUNDATION BY OTHERS.

LTR	REVISION	BY	DATE	DRAWN BY	PROJECT	TITLE	DWG. NO.	SHEET
						BLOCKING / TIE DOWN	V2464-3	S-2
					SCALE:		3/16"=1'-0"	