



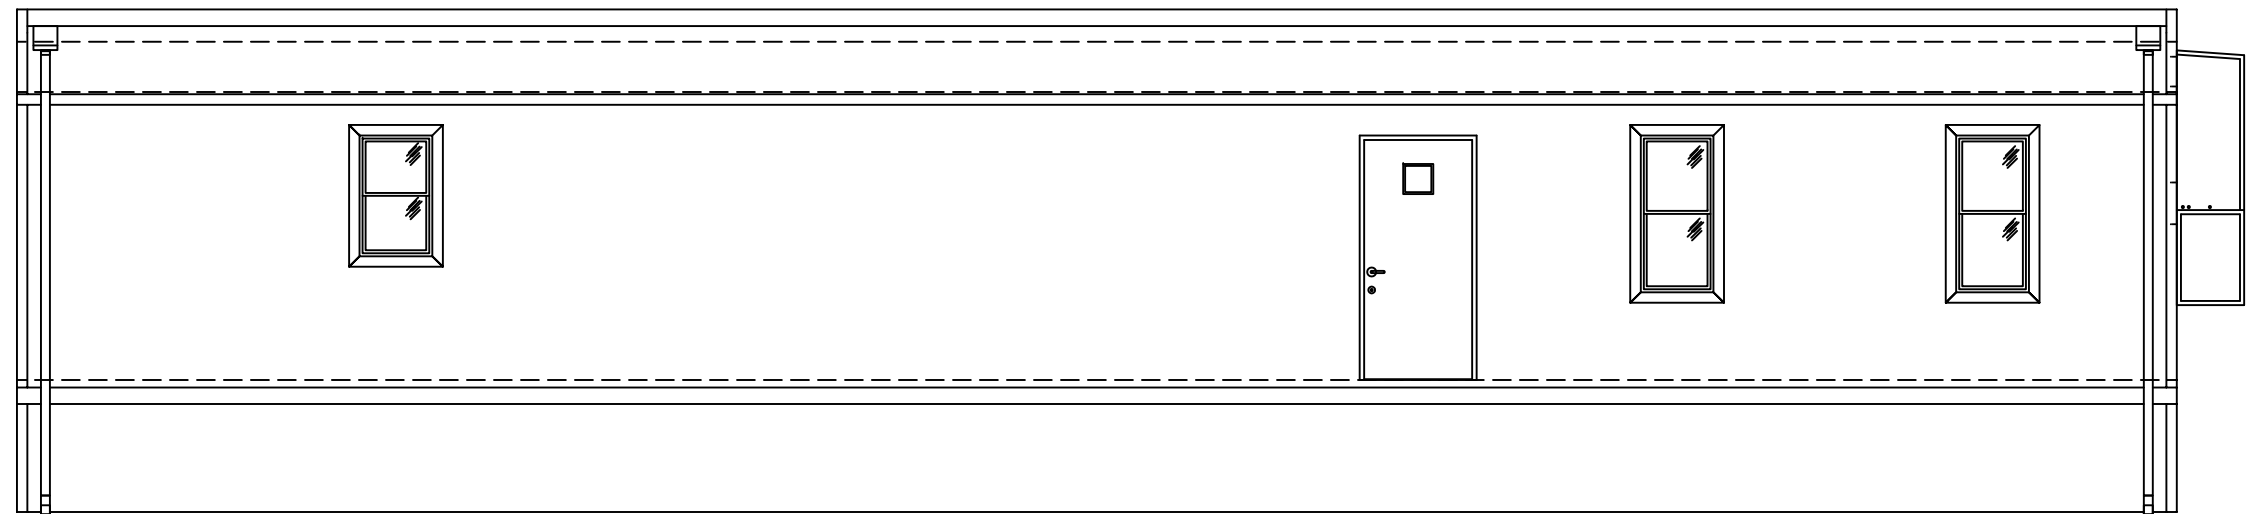


1	revised frame to perimeter type (sheets S2, F1, &F2) lrs	3-20-12	THIS DRAWING AND ALL INFORMATION CONTAINED HEREON IS THE PROPERTY OF WHITLEY MFG. CO. INC., AND IS NOT TO BE REPRODUCED WITHOUT THE EXPRESS PERMISSION OF WHITLEY MFG. CO., INC.	 201 WEST FIRST STREET P.O. BOX 496 SOUTH WHITLEY, IN 46787 PHONE: 260.723.6131 FAX: 260.723.6949 www.whitleyman.com 2755 FORT WAYNE ROAD P.O. BOX 505 ROCHESTER, IN 46755 PHONE: 574.223.4934 FAX: 574.223.8779 www.whitleyman.com	Drawn By: lrs-sub	Building Elevations MODEL #6910 64'X24' (2) 60'-0"X11'-9" MODULES	Serial No.	Date 2-15-12
			Checked By: PG		Quote No. 37462-16 REV1		Scale: 3/16" = 1'-0"	
			Rev: 1		Model No. 6910		Page No. A1	
NO.	REVISION	DATE	WHITLEY MFG. CO. INC., ASSUMES NO RESPONSIBILITY FOR UNAUTHORIZED USE OF THIS DRAWING.		Job No.			

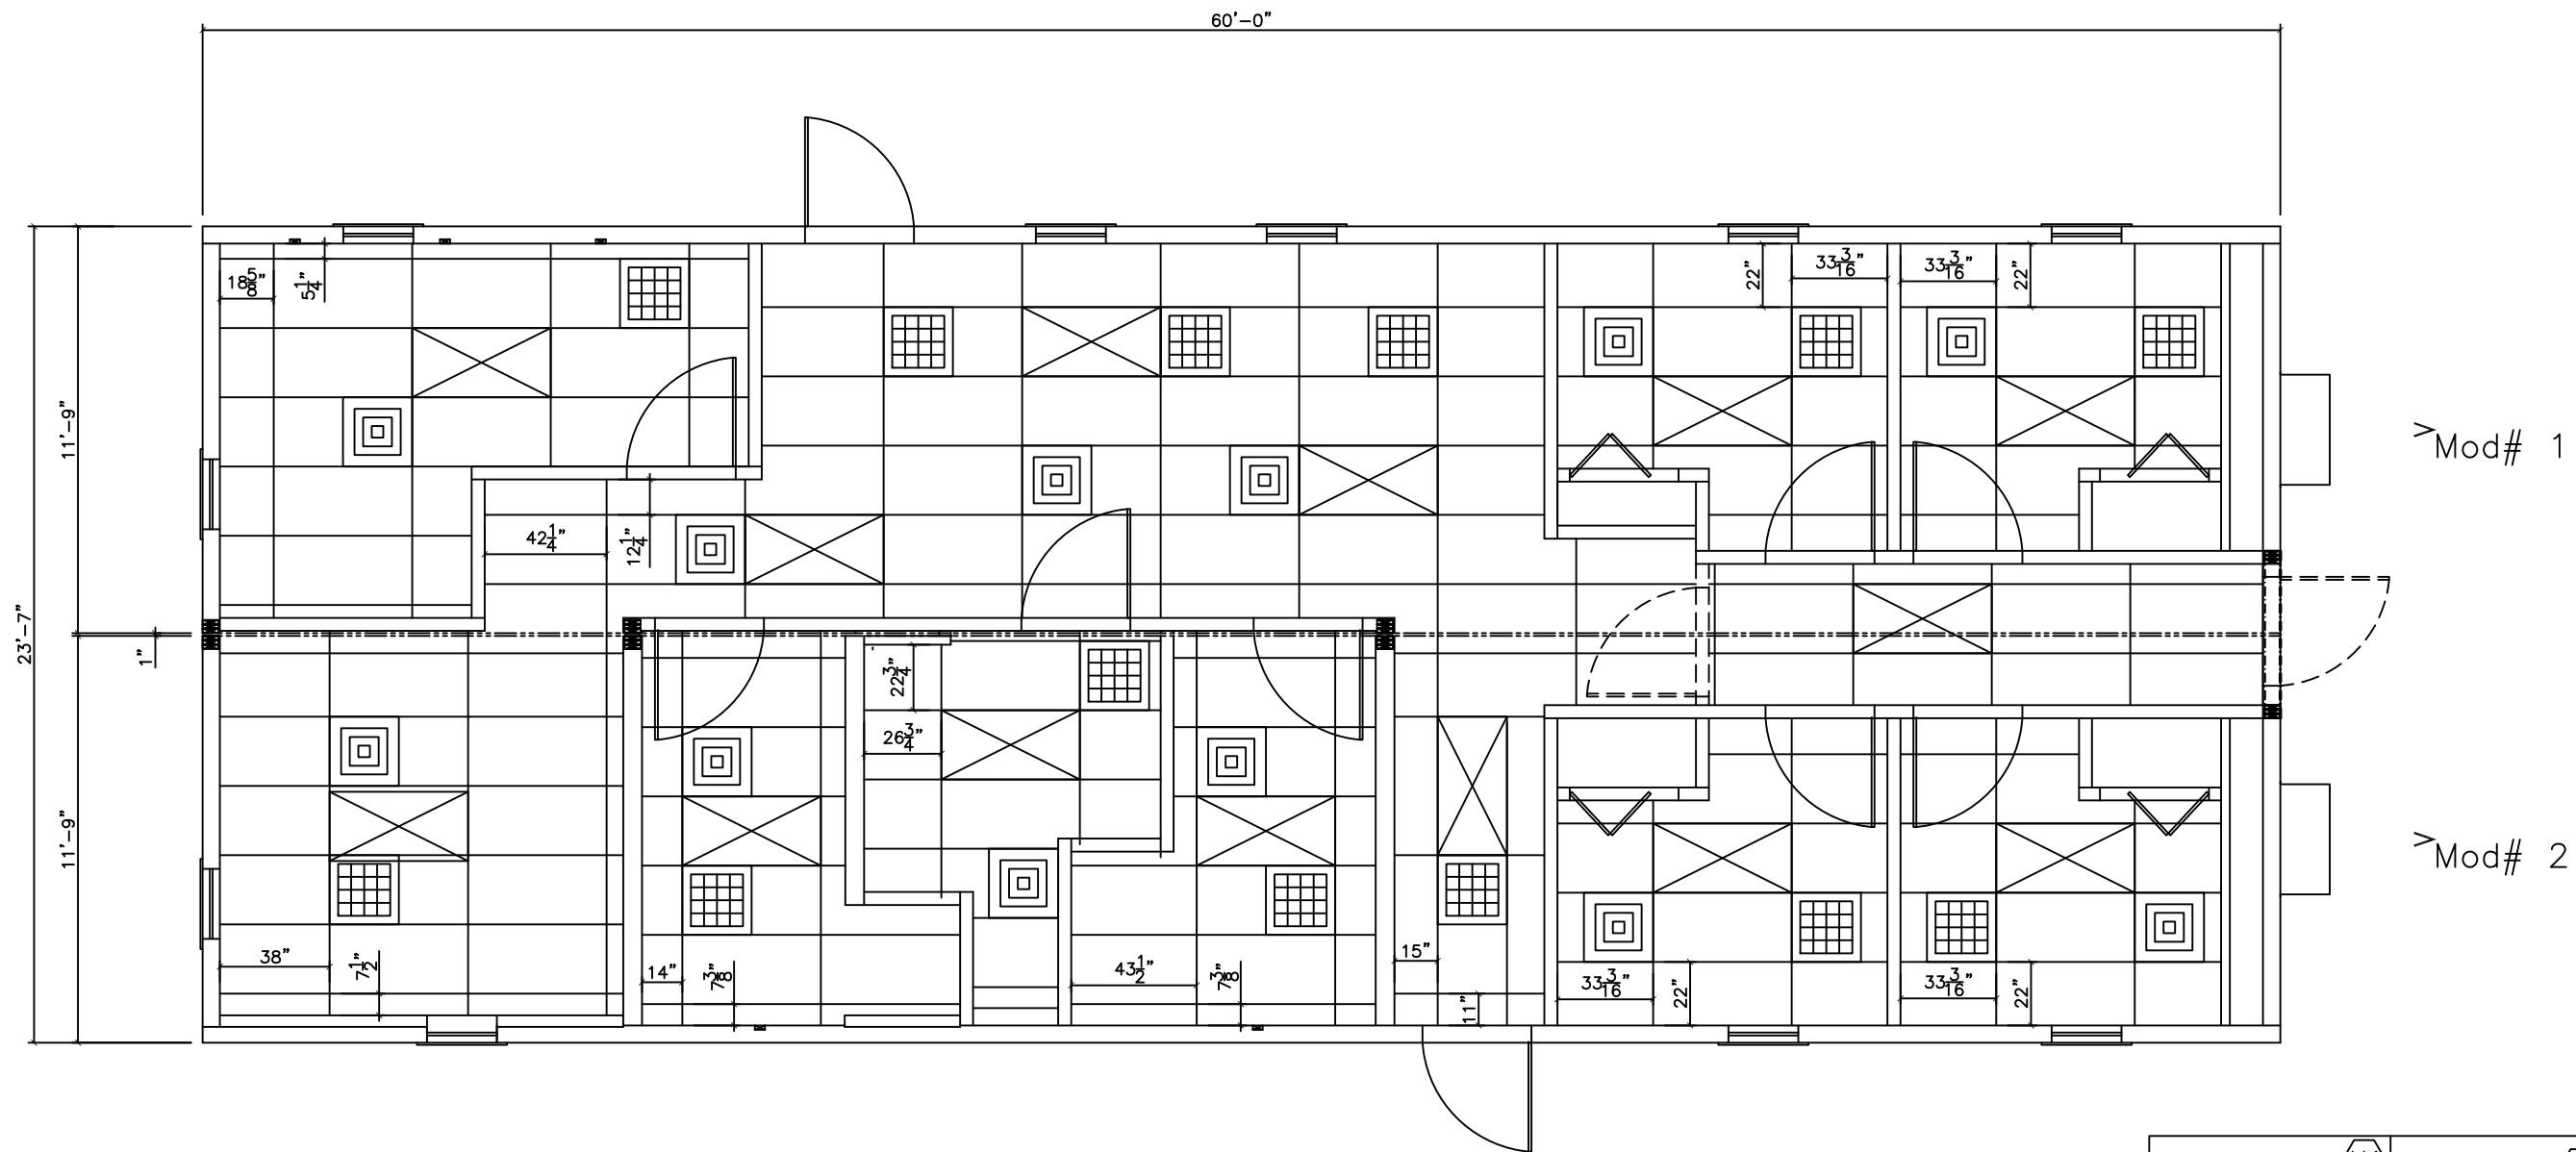


	H1		H27		J15
	H9		H28		J17
	H13		H29		J20
	H19		H30		K4
	H21		H32		K6
	H22		H40		K7
	H24		J13		K7a
	H25		J14		K10
					A5

1	revised frame to perimeter type (sheets S2, F1, &F2) lrs	3-20-12	THIS DRAWING AND ALL INFORMATION CONTAINED HEREON IS THE PROPERTY OF WHITLEY MFG. CO. INC., AND IS NOT TO BE REPRODUCED WITHOUT THE EXPRESS PERMISSION OF WHITLEY MFG. CO., INC.	 WHITLEY MANUFACTURING	201 WEST FIRST STREET P.O. BOX 496 SOUTH WHITLEY, IN 46787 PHONE: 260.723.5131 FAX: 260.723.6949 www.whitleyman.com 2755 FORT WAYNE ROAD P.O. BOX 505 ROCHESTER, IN 46975 PHONE: 574.223.4934 FAX: 574.223.8779 www.whitleyman.com	Drawn By: lrs-sub	Reflected Ceiling Plan MODEL #6910 64'X24' (2) 60'-0"X11'-9" MODULES	Serial No. 2-15-12	Date
			Checked By: PG		Quote No. 37462-16 REV1	Scale: 3/16"=1'-0"			
			Rev: 1		Model No. 6910	Page No. A3			
NO.	REVISION	DATE	WHITLEY MFG. CO. INC., ASSUMES NO RESPONSIBILITY FOR UNAUTHORIZED USE OF THIS DRAWING.		Job No.				

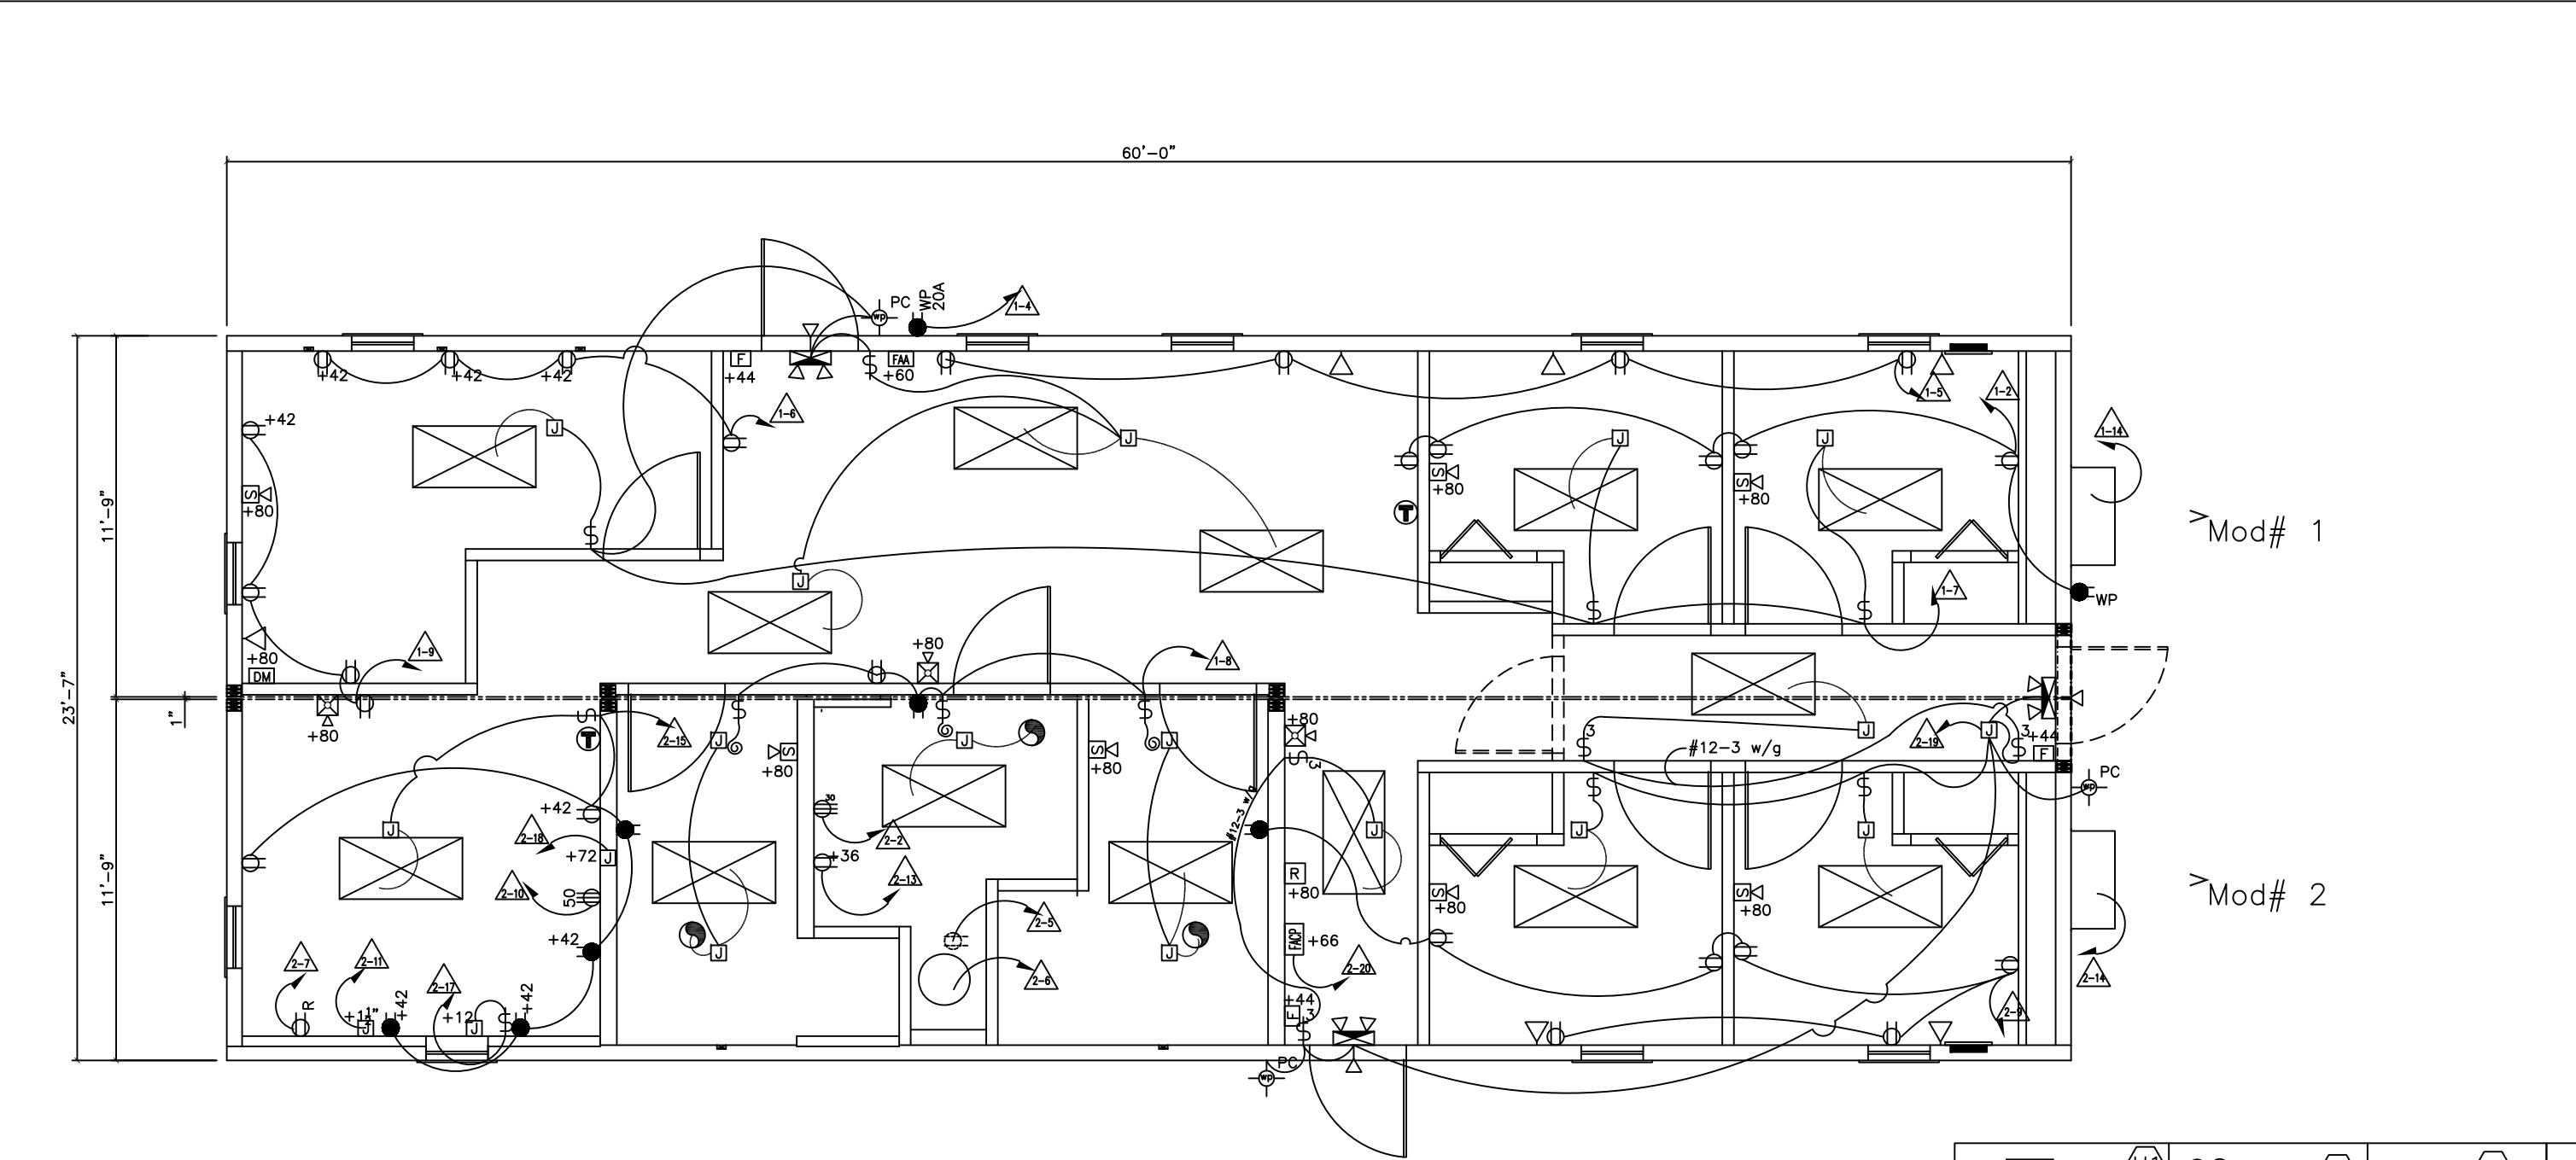

	H1		H27		J15
	H9		H28		J17
	H13		H29		J20
	H19		H30		K4
	H21		H32		K6
	H22		H40		K7
	H24		J13		K7a
	H25		J14		K10
					A5

1	revised frame to perimeter type (sheets S2, F1, &F2) lrs	3-20-12	THIS DRAWING AND ALL INFORMATION CONTAINED HEREON IS THE PROPERTY OF WHITLEY MFG. CO. INC., AND IS NOT TO BE REPRODUCED WITHOUT THE EXPRESS PERMISSION OF WHITLEY MFG. CO., INC.	 201 WEST FIRST STREET P.O. BOX 498 SOUTH WHITLEY, IN 46787 PHONE: 260.723.5131 FAX: 260.723.6949 www.whitleyman.com 2755 FORT WAYNE ROAD P.O. BOX 505 ROCHESTER, IN 46975 PHONE: 574.223.4934 FAX: 574.223.8779 www.whitleyman.com	Drawn By: lrs-sub	Electrical Plan MODEL #6910 64'X24' (2) 60'-0"X11'-9" MODULES	Serial No.	Date
			Checked By: PG				Quote No.	Scale
							37462-16 REV1	3/16" = 1'-0"
					Rev: 1		6910	Page No.
NO.	REVISION	DATE	WHITLEY MFG. CO. INC., ASSUMES NO RESPONSIBILITY FOR UNAUTHORIZED USE OF THIS DRAWING.				Job No.	E1

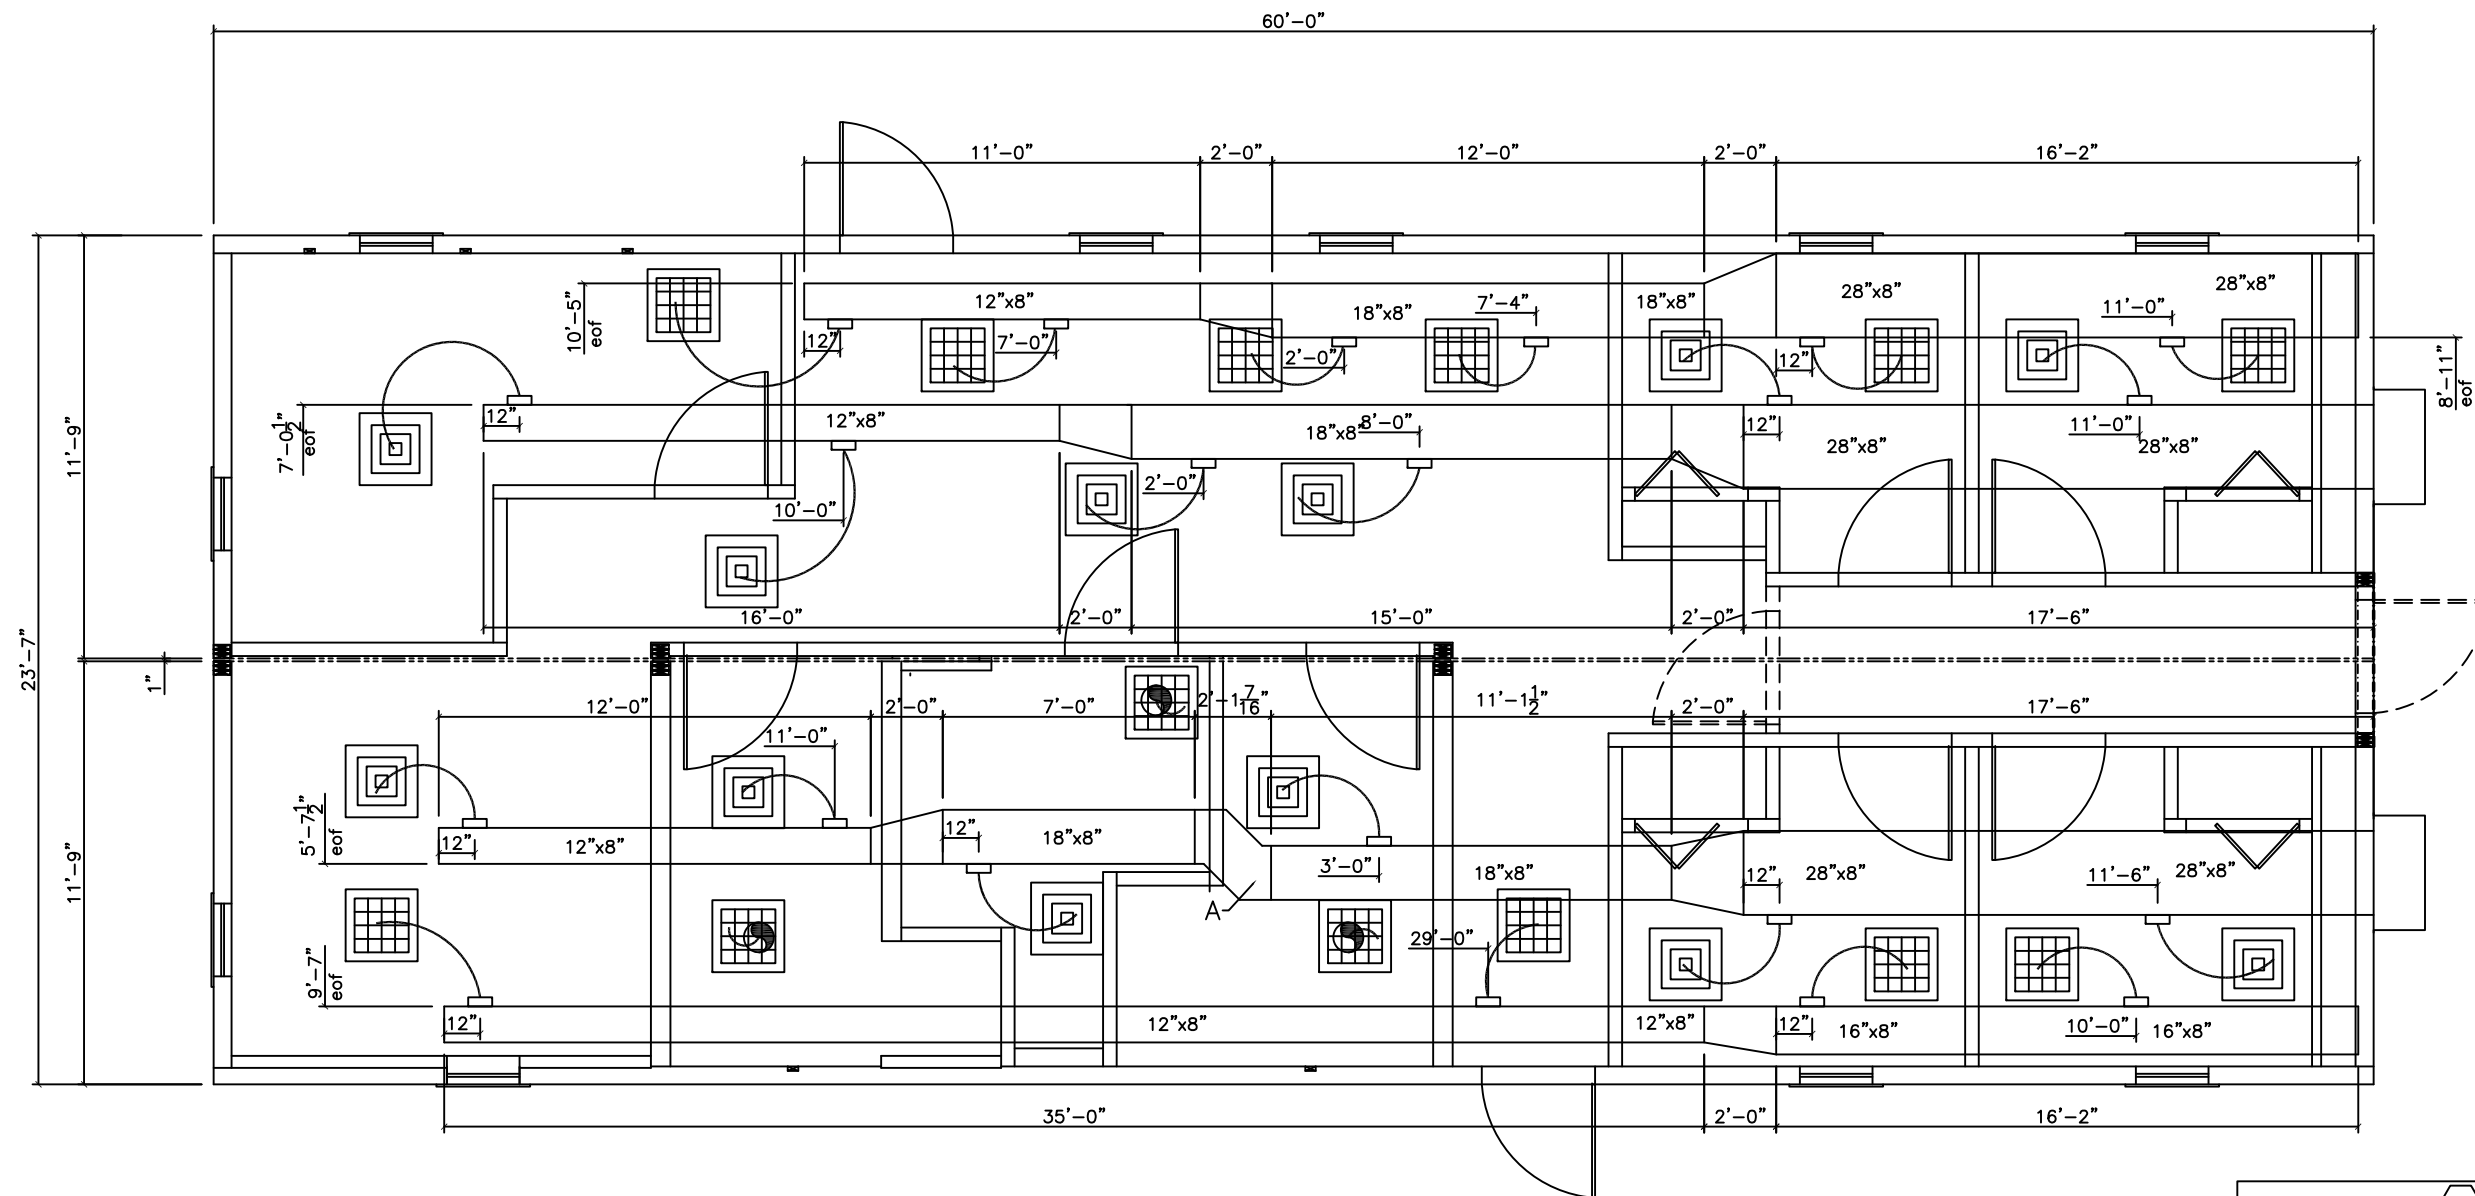


Mod# 1

Mod# 2

NOTE: DUCT MADE FROM 1 1/2" FIBERGLASS DUCT.

DUCTS, DUCT LINERS, DIFFUSERS, BREAKAWAYS, DAMPERS AND DAMPER FASTENERS SHALL BE FABRICATED AND INSTALLED PER SMACNA 2003 FIBROUS GLASS DUCT AND SMACNA 2005 HVAC DUCT CONSTRUCTION STANDARDS.


DUCTS BOTH FLEX AND RIDGID SHALL BE INSTALLED PER DUCT MANUFACTURERS INSTALLATION INSTRUCTIONS AND THE LISTING PROCEDURE.

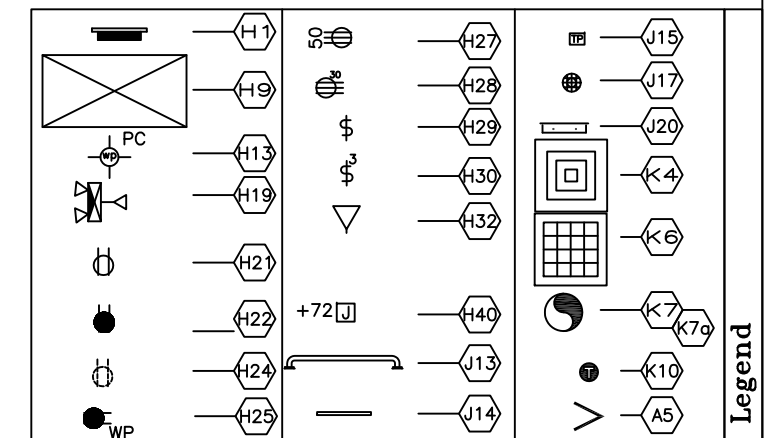

1	revised frame to perimeter type (sheets S2, F1, &F2) lrs	3-20-12	THIS DRAWING AND ALL INFORMATION CONTAINED HEREON IS THE PROPERTY OF WHITLEY MFG. CO. INC., AND IS NOT TO BE REPRODUCED WITHOUT THE EXPRESS PERMISSION OF WHITLEY MFG. CO., INC.	 WHITLEY MANUFACTURING	201 WEST FIRST STREET P.O. BOX 496 SOUTH WHITLEY, IN 46787 PHONE: 260.723.5131 FAX: 260.723.6949 www.whitleyman.com 2755 FORT WAYNE ROAD P.O. BOX 505 ROCHESTER, IN 46975 PHONE: 574.223.4934 FAX: 574.223.8779 www.whitleyman.com	Drawn By: lrs-sub	Mechanical Plan MODEL #6910 64'X24' (2) 60'-0"X11'-9" MODULES	Serial No.	Date
			Checked By: PG			Quote No.		Scale:	
			Rev: 1			Model No.		Page No.	
NO.	REVISION	DATE	WHITLEY MFG. CO. INC., ASSUMES NO RESPONSIBILITY FOR UNAUTHORIZED USE OF THIS DRAWING.			Job No.		M1	
								37462-16 REV1	3/16"=1'-0"

SUPPLY:

1. WATER SUPPLY LINES TO BE PEX EXCEPT WHERE NOTED TO BE TYPE-L COPPER
2. ALL PIPES TO BE SECURED @ 32" O.C. HORIZ AND 10' VERT.
3. WATER TEMPERATURE FACTORY SET @ 120 DEGREES F. (CONTROLS BEHIND COVER PANEL.)
4. A SHUT-OFF VALVE IS REQUIRED FOR EACH FIXTURE.
5. WATER HAMMER ARRESTORS SHALL BE PROVIDED AS REQUIRED WITH QUICK-CLOSING VALVES.
6. WATER HEATER TO BE EQUIPPED WITH DRAIN COCK.
7. DIELECTRIC UNIONS TO BE USED @ CONNECTIONS OF WATER LINES TO WATER HEATER.
8. COLD WATER INLET TO BE WITH A SHUT-OFF VALVE ABOVE FLOOR AND NEAR WATERHEATER.
9. FULL SIZE SHUT-OFF VALVE TO BE PROVIDED BETWEEN BUILDING AND WATER MAIN(METER).
10. SUPPLY SYSTEM DESIGNED FOR INLET PRESSURES OF 60 TO 80 PSI.
11. WATER HEATERS WITH BOTTOM AND/OR SIDE INLETS SHALL HAVE A VACUUM RELIEFVALVE INSTALLED (IF APPLICABLE) IN THE COLD WATER LINE. LOCATE ABOVE THE TOP OFTHE WATER HEATER PER MANUFACTURERS RECOMMENDED INSTRUCTIONS.
12. IN CONCEALED LOCATIONS AT PLUMBING PIPING, PROTECTIVE SHIELD PLATES SHALL BE INSTALLED THAT ARE A MINIMUM 1/16" THICK STEEL AND SHALL COVER THE AREA OF THE PIPE WHERE THE MEMBER IS NOTCHED OR BORED AND SHALL EXTEND A MINIMUM OF 2 INCHES ABOVE SOLE PLATES AND BELOW TOP PLATES.

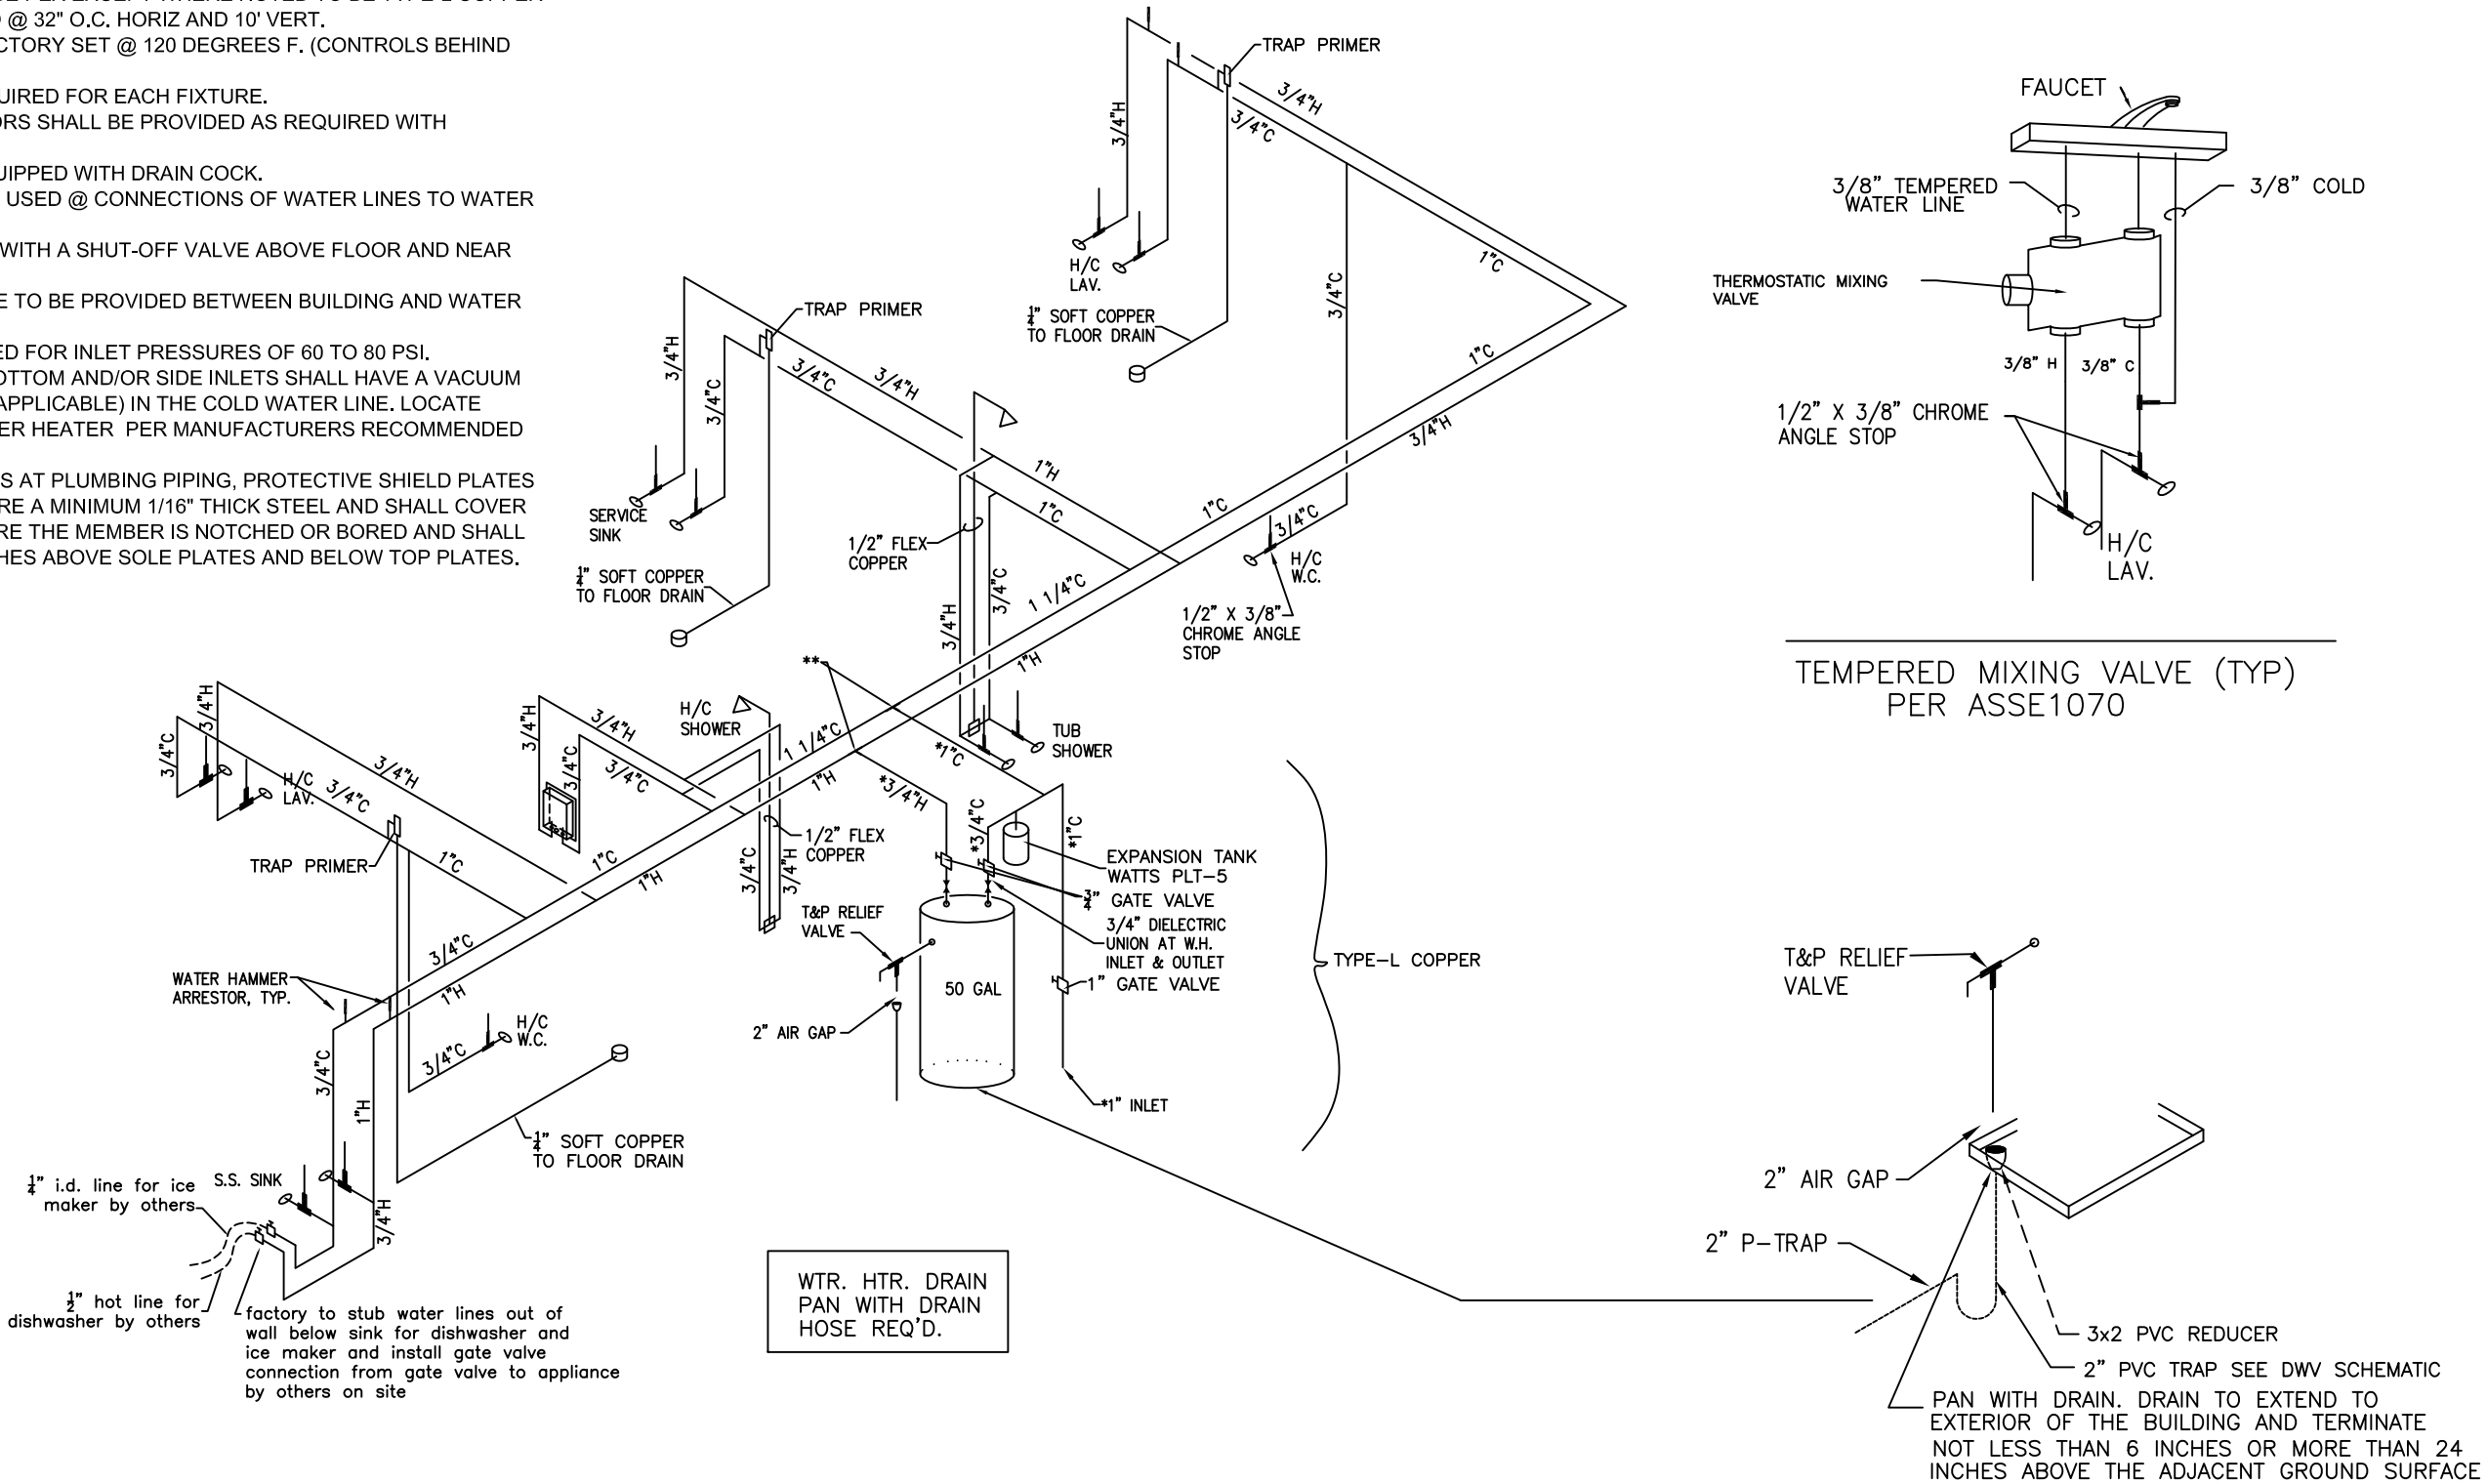


1	revised frame to perimeter type (sheets S2, F1, &F2) lrs	3-20-12	THIS DRAWING AND ALL INFORMATION CONTAINED HEREON IS THE PROPERTY OF WHITLEY MFG. CO. INC., AND IS NOT TO BE REPRODUCED WITHOUT THE EXPRESS PERMISSION OF WHITLEY MFG. CO., INC.		201 WEST FIRST STREET P.O. BOX 498 SOUTH WHITLEY, IN 46787 PHONE: 260.723.5131 FAX: 260.723.6949 www.whitleyman.com 2755 FORT WAYNE ROAD P.O. BOX 505 ROCHESTER, IN 46975 PHONE: 574.223.4934 FAX: 574.223.8779 www.whitleyman.com	Drawn By: lrs-sub	Plumbing Schematics-Supply MODEL #6910 64'X24' (2) 60'-0"X11'-9" MODULES	Serial No. 2-15-12	Date
						Checked By: PG		Quote No. 37462-16 REV1	Scale:
						Rev: 1		Model No. 6910	Page No.
NO.	REVISION	DATE	WHITLEY MFG. CO. INC., ASSUMES NO RESPONSIBILITY FOR UNAUTHORIZED USE OF THIS DRAWING.					Job No.	P1

DWV:


1. DWV PIPING TO BE SCHEDULE 40 PVC.
2. ALL PIPES TO BE SECURED @ 48" O.C.
3. ALL CLEAN-OUTS SHALL BE ACCESSIBLE, PROVIDED @ THE BASE OF ALL WASTE AND SOIL STACKS, AND PROVIDED SO THAT ALL HORIZONTAL PIPING CAN BE REACHED WITH A CLEANOUT TOOL WITHOUT PASSING THROUGH MORE THAN 45 DEGREES OF TURN.
4. HORIZONTAL BRANCH PIPES 2 1/2" AND SMALLER IN DIAMETER TO HAVE A MINIMUM 1/4" PER FOOT SLOPE; PIPES 3" TO 6" DIAMETER TO HAVE A MINIMUM OF 1/8" PER FOOT SLOPE.
5. VENTS SHALL BE A MINIMUM OF 3" IN DIAMETER FOR 12" ABOVE AND 24" BELOW ROOF AND SHALL NOT BE LOCATED WITHIN 10" HORIZONTALLY OF OTHER VENT OPENINGS.
6. ALL VERTICAL TO HORIZONTAL OR HORIZONTAL TO HORIZONTAL CHANGE OF DIRECTION SHALL BE THROUGH A LONG TURN T-Y OR COMBINATION WYE AND EIGHTH BEND.
7. ALL HORIZONTAL TO VERTICAL CHANGE OF DIRECTION SHALL BE THROUGH A SANITARY TEE, OR IF @ THE SAME LEVEL ON A VERTICAL STACK, THROUGH AN APPROVED DOUBLE FIXTURE FITTING.
8. IN CONCEALED LOCATIONS AT PLUMBING PIPING, PROTECTIVE SHIELD PLATES SHALL BE INSTALLED THAT ARE A MINIMUM 1/16" THICK STEEL AND SHALL COVER THE AREA OF THE PIPE WHERE THE MEMBER IS NOTCHED OR BORED AND SHALL EXTEND A MINIMUM OF 2 INCHES ABOVE SOLE PLATES AND BELOW TOP PLATES.

FIELD NOTE:


1. ALL LINES REPRESENTED BY A BROKEN LINE ON SCHEMATIC DRAWINGS SHALL BE PROVIDED AND INSTALLED ON SITE PER DEALER CONTRACTURAL AGREEMENT.

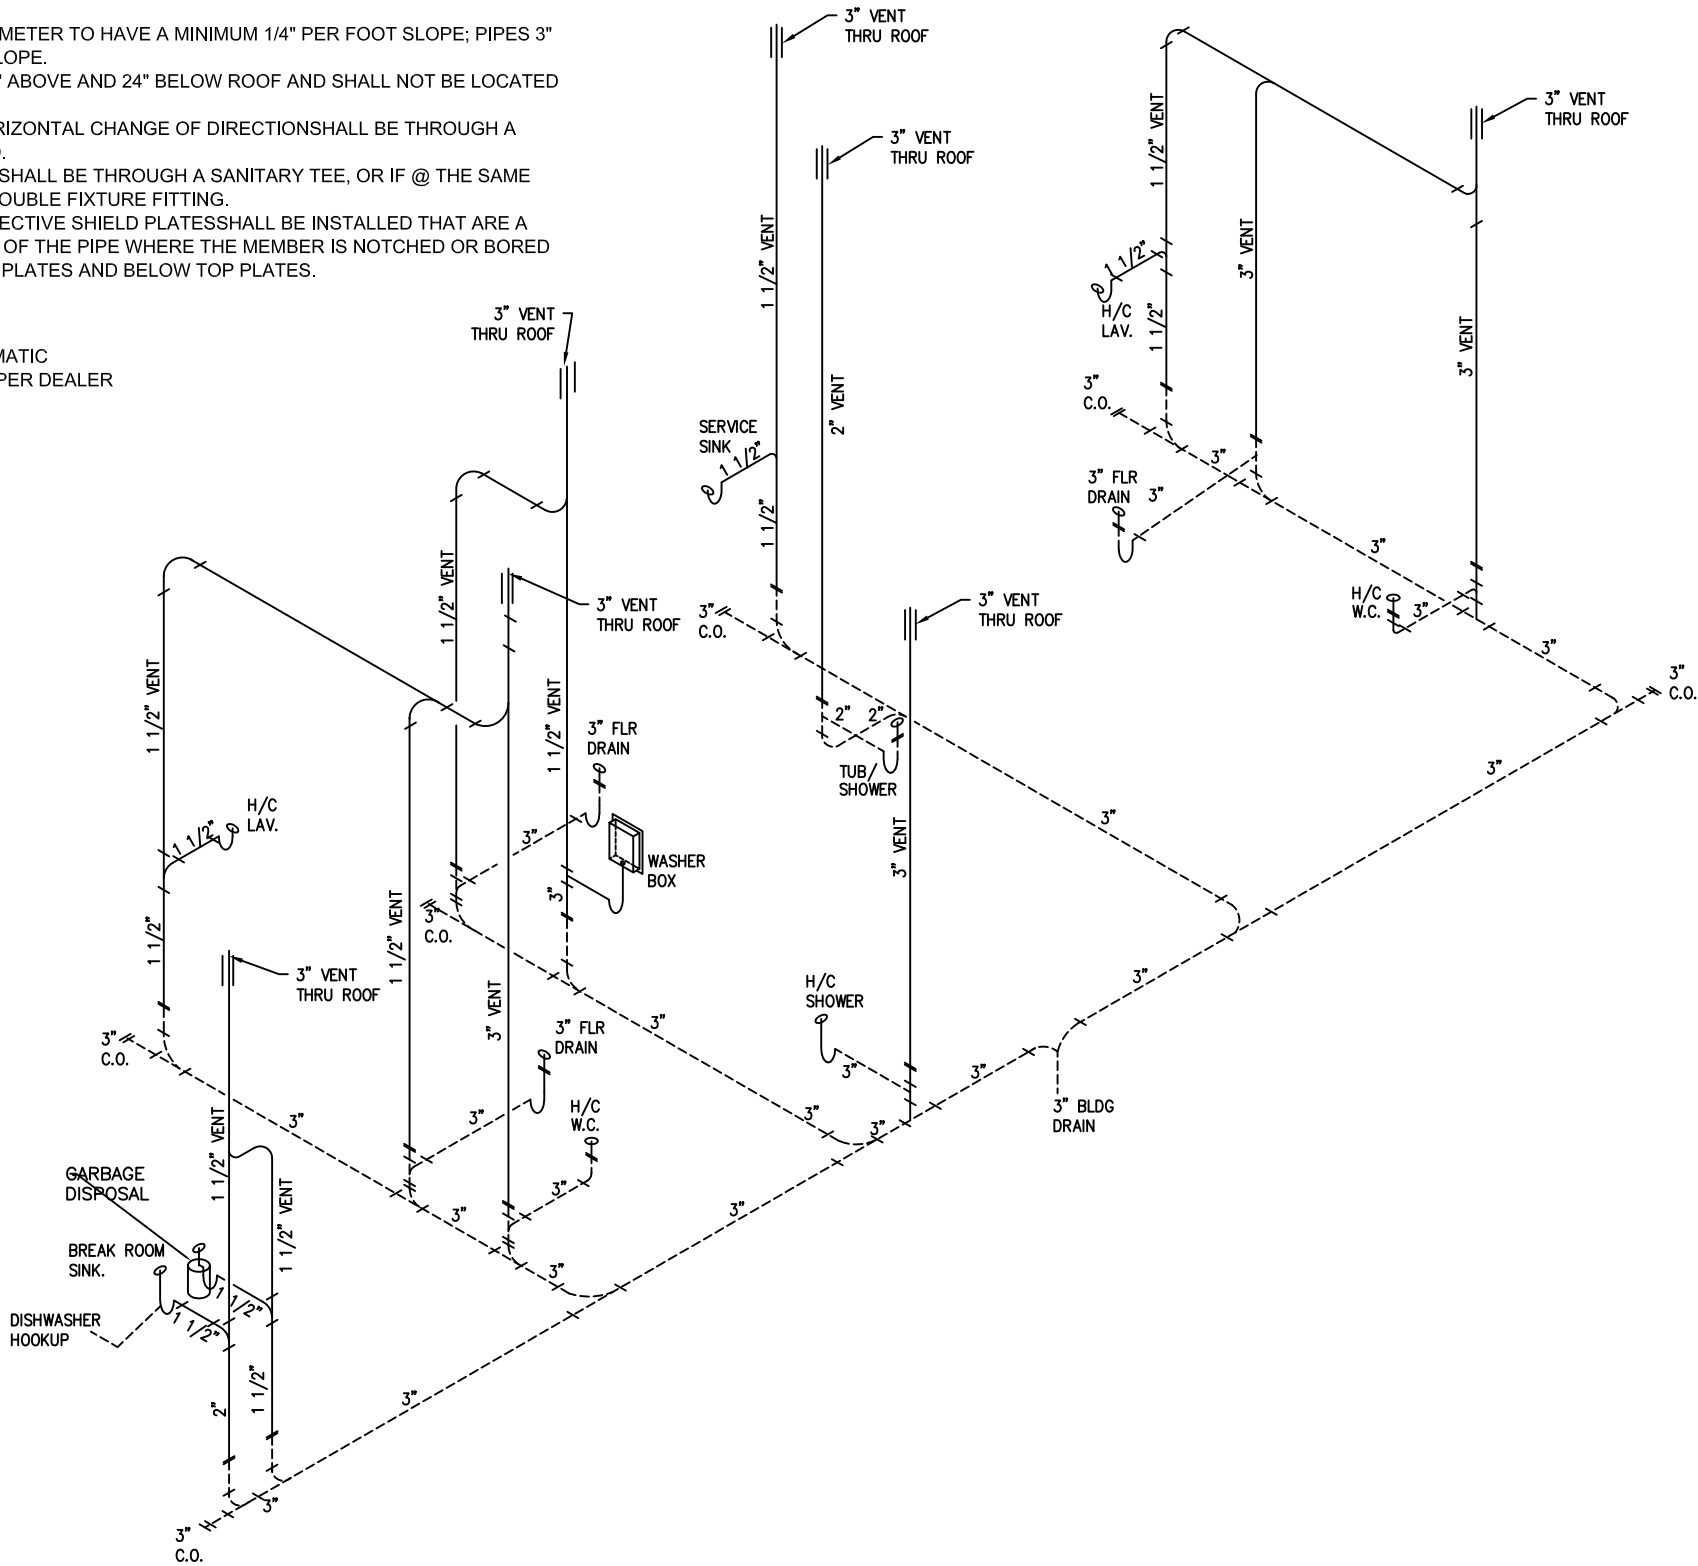


1	revised frame to perimeter type (sheets S2, F1, &F2) lrs	3-20-12	THIS DRAWING AND ALL INFORMATION CONTAINED HEREON IS THE PROPERTY OF WHITLEY MFG. CO. INC., AND IS NOT TO BE REPRODUCED WITHOUT THE EXPRESS PERMISSION OF WHITLEY MFG. CO., INC. WHITLEY MFG. CO. INC., ASSUMES NO RESPONSIBILITY FOR UNAUTHORIZED USE OF THIS DRAWING.	WM WHITLEY MANUFACTURING	201 WEST FIRST STREET P.O. BOX 498 SOUTH WHITLEY, IN 46787 PHONE: 260.723.5131 FAX: 260.723.6949 www.whitleyman.com 2755 FORT WAYNE ROAD P.O. BOX 505 ROCHESTER, IN 46975 PHONE: 574.223.4934 FAX: 574.223.8779 www.whitleyman.com	Drawn By: lrs-sub	Plumbing Schematics-DWV MODEL #6910	Serial No.	Date 2-15-12
						Checked By: PG		Quote No. 37462-16 REV1	Scale: NTS
						Rev: 1		Model No. 6910	Page No.
							64'X24' (2) 60'-0"X11'-9" MODULES	Job No.	P2
NO.	REVISION	DATE							

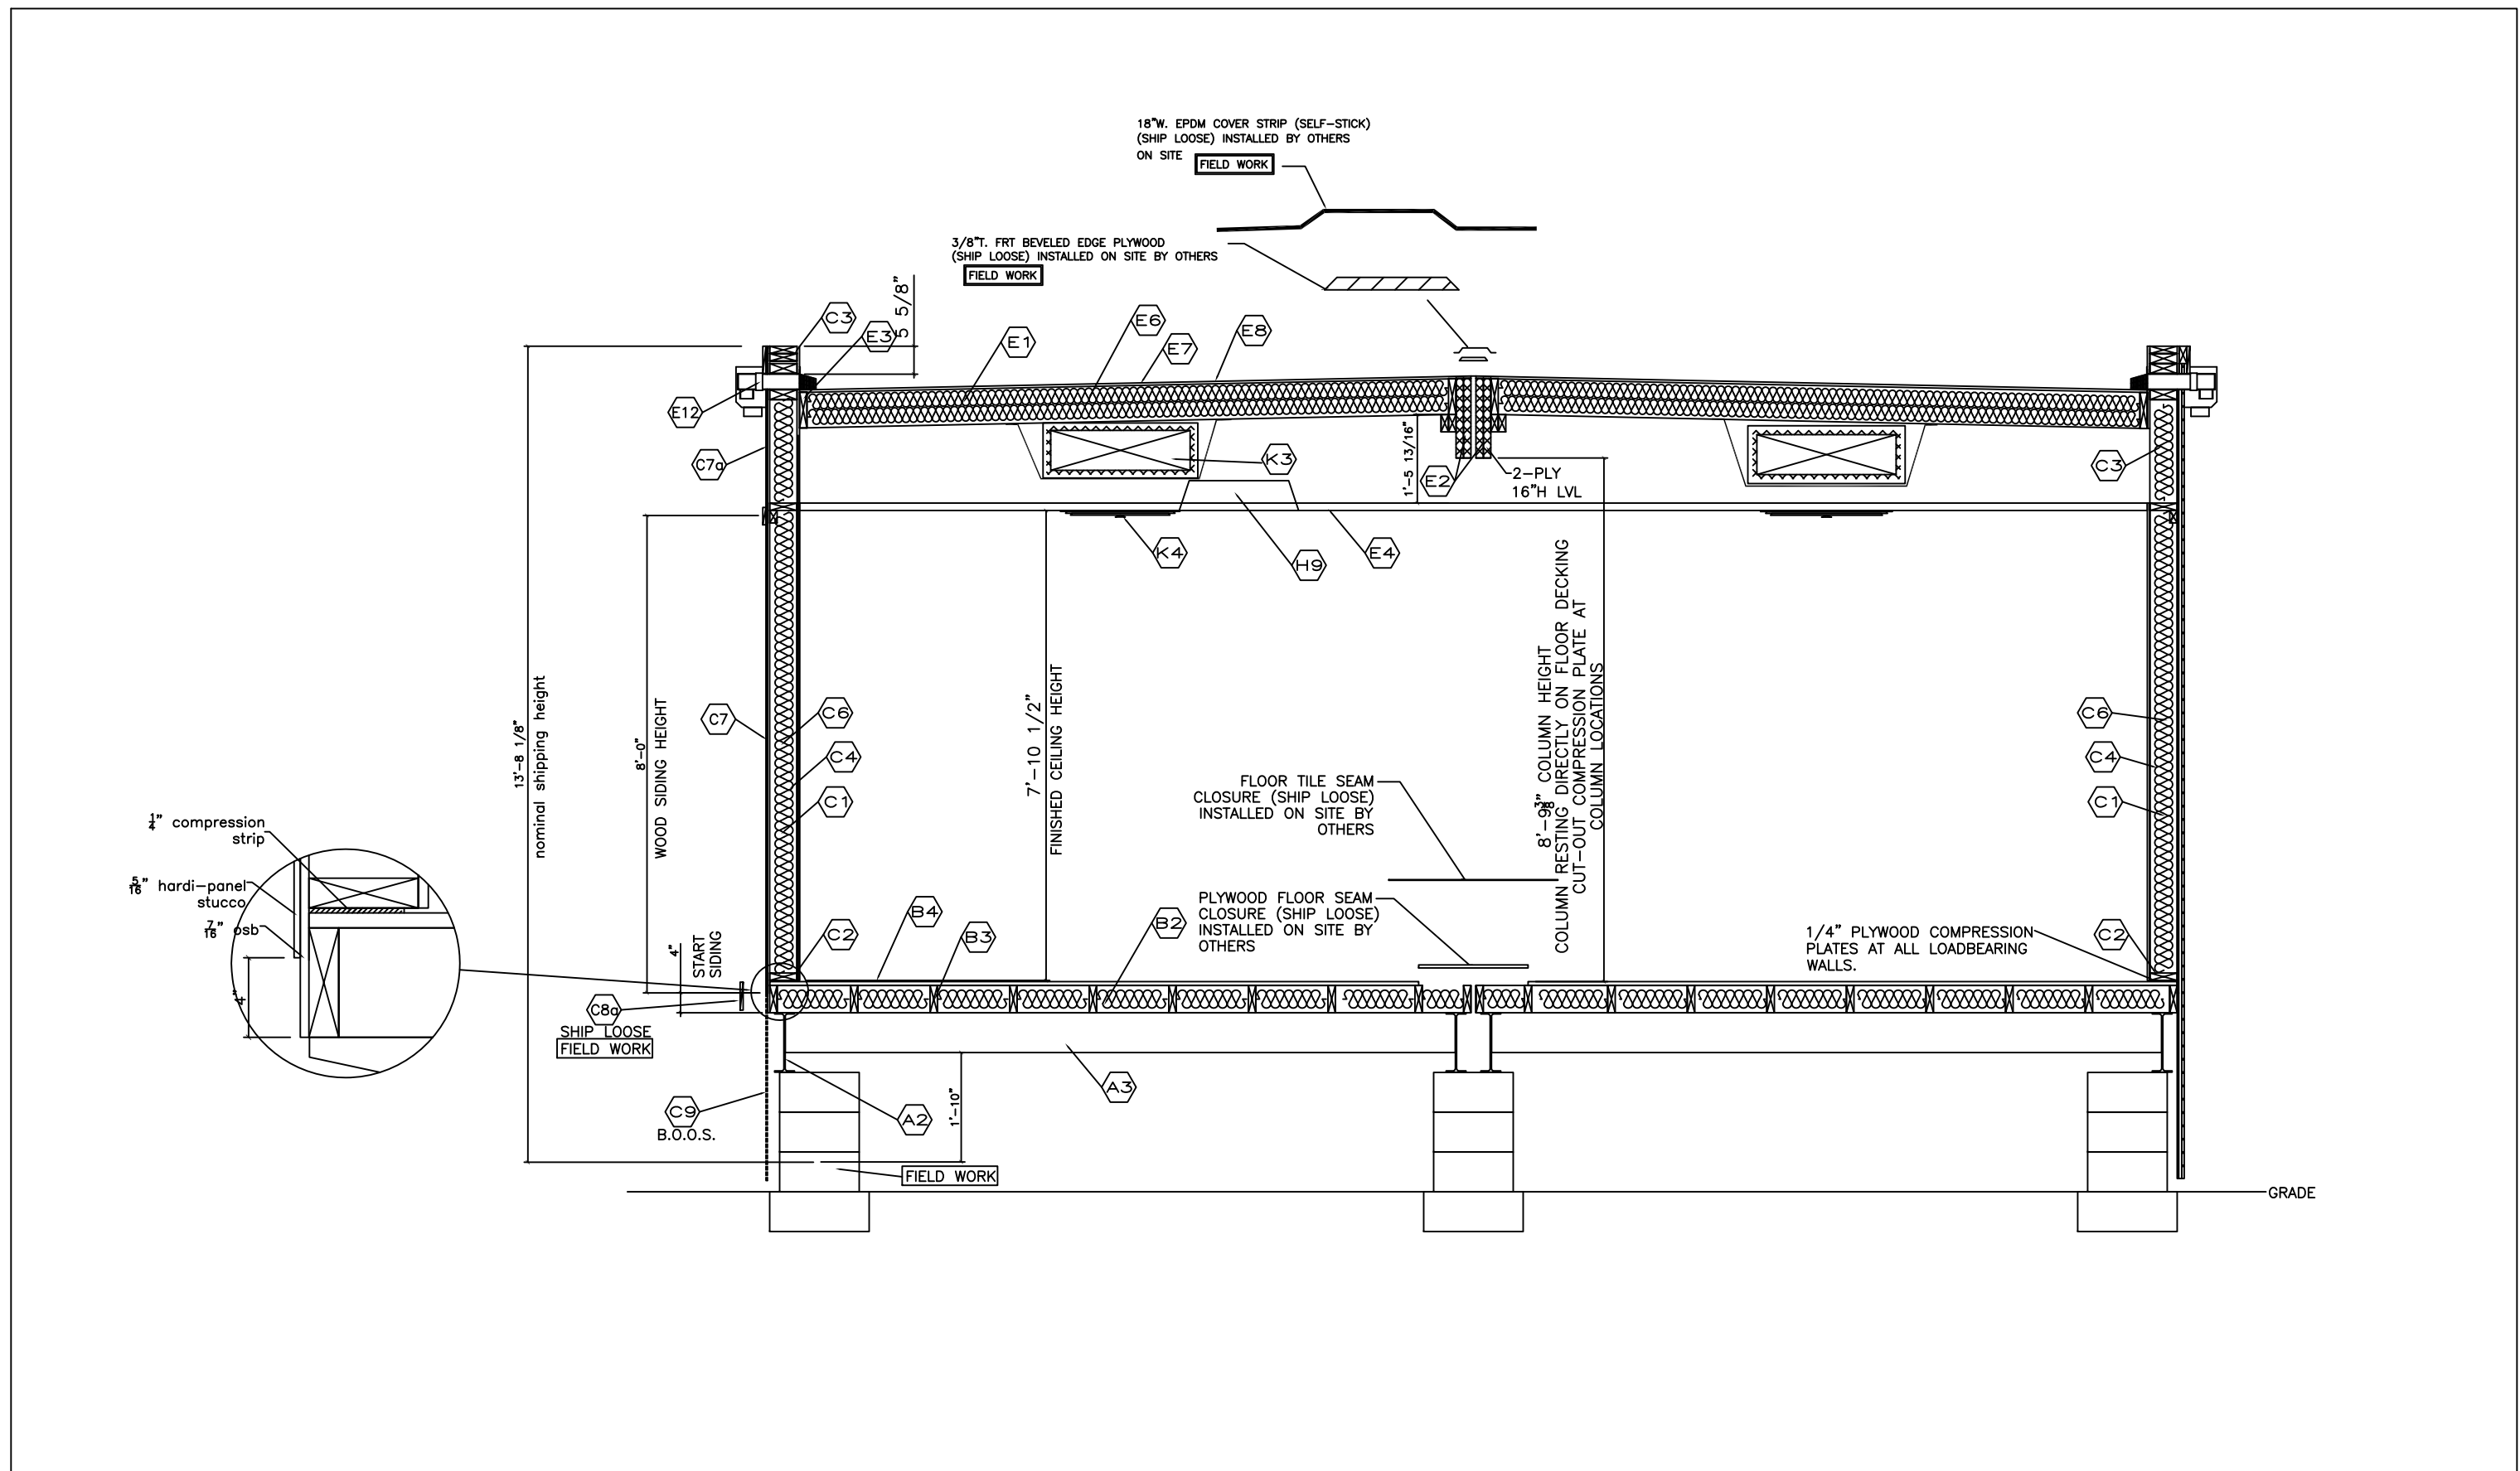


1	revised frame to perimeter type (sheets S2, F1, &F2) lrs	3-20-12	THIS DRAWING AND ALL INFORMATION CONTAINED HEREON IS THE PROPERTY OF WHITLEY MFG. CO. INC., AND IS NOT TO BE REPRODUCED WITHOUT THE EXPRESS PERMISSION OF WHITLEY MFG. CO., INC.	 201 WEST FIRST STREET P.O. BOX 498 SOUTH WHITLEY, IN 46787 PHONE: 260.723.5131 FAX: 260.723.6949 www.whitleyman.com 2755 FORT WAYNE ROAD P.O. BOX 505 ROCHESTER, IN 46975 PHONE: 574.223.4934 FAX: 574.223.8779 www.whitleyman.com	Drawn By: lrs-sub	Cross Section MODEL #6910 64'X24' (2) 60'-0"X11'-9" MODULES	Serial No. 2-15-12	Date
					Checked By: PG		Quote No. 37462-16 REV1	Scale: N.T.S.
					Rev: 1		Model No. 6910	Page No. S2
NO.	REVISION	DATE	WHITLEY MFG. CO. INC., ASSUMES NO RESPONSIBILITY FOR UNAUTHORIZED USE OF THIS DRAWING.				Job No.	

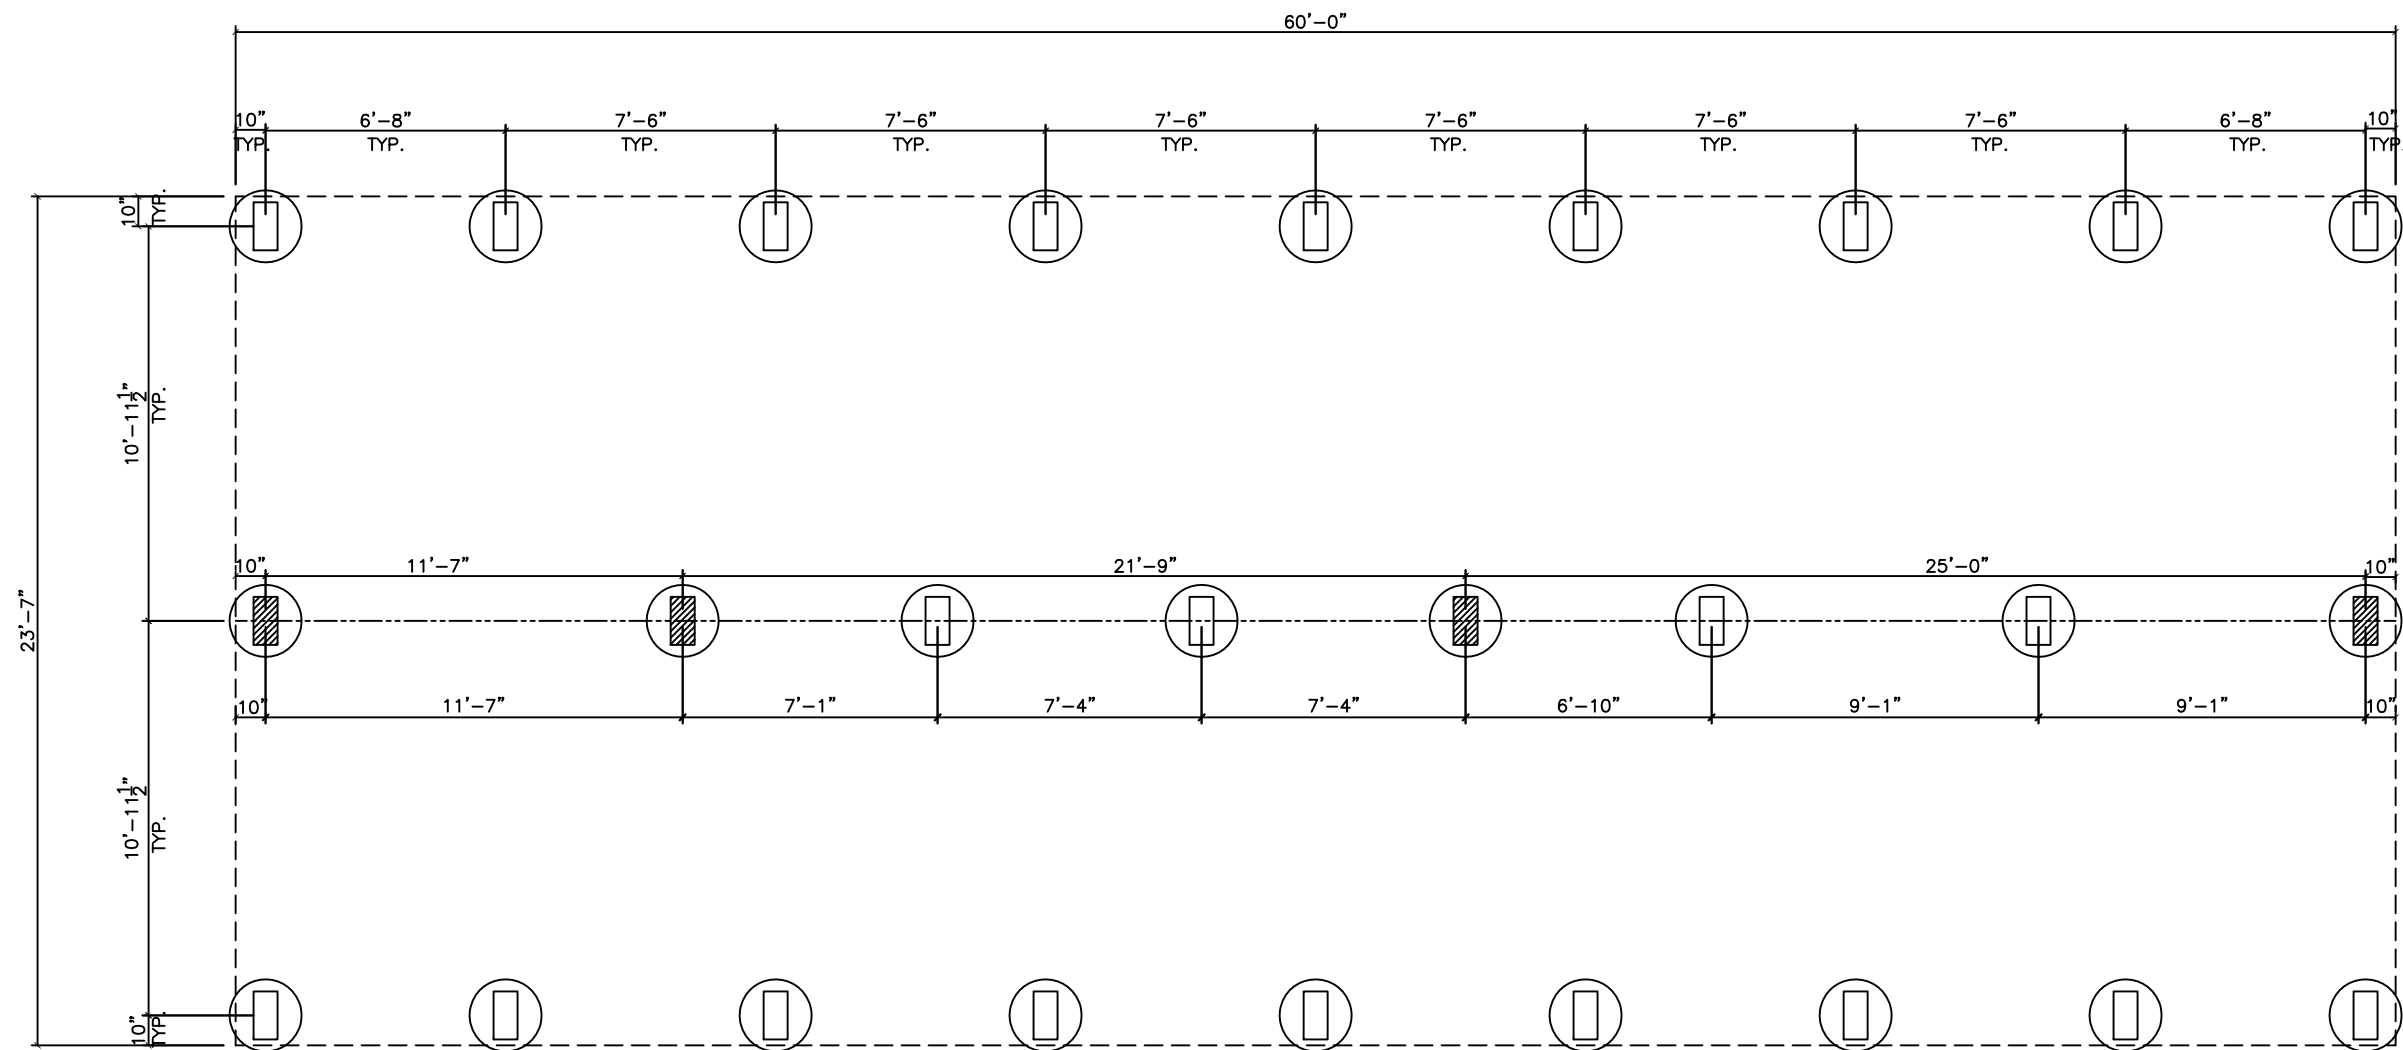


SEE SHEET F2 FOR
FOUNDATION NOTES
AND TIE DOWN
DETAILS

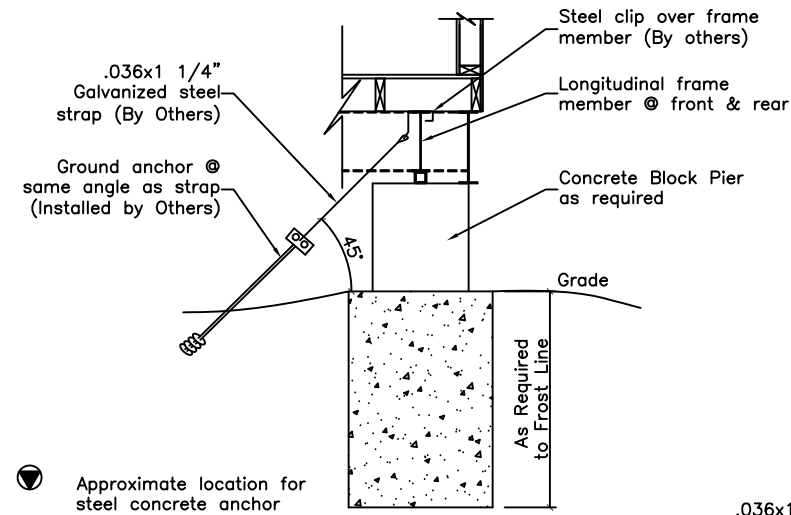


Pier Detail (Standard)
(NTS)

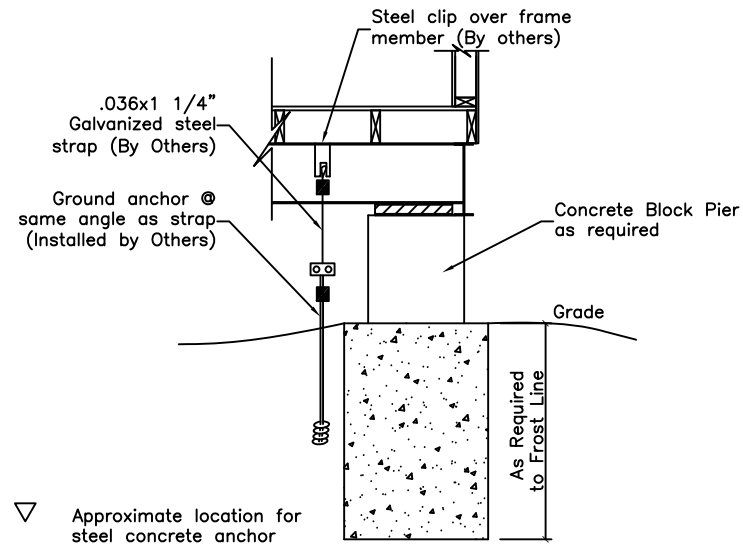

Pier Detail (Option #1)
(NTS)

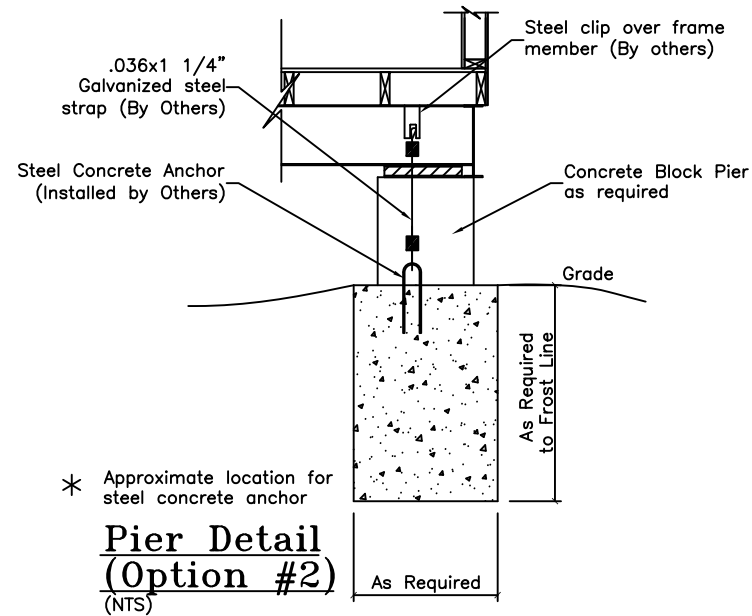

Pier Detail (Option #2)
(NTS)

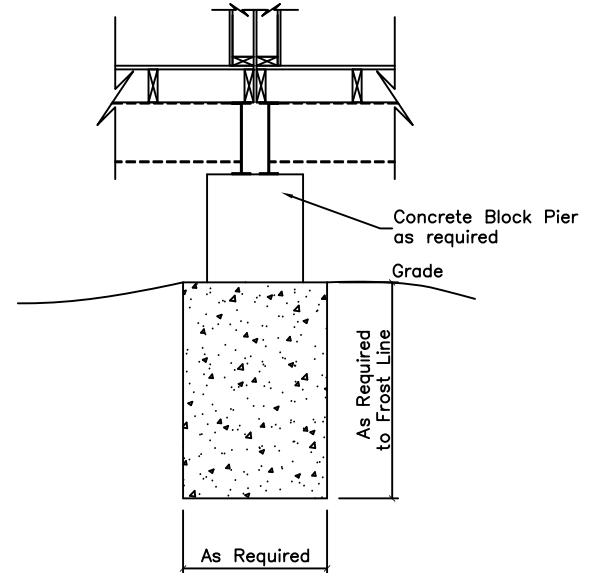

Pier Detail Mateline (Standard)
(NTS)









Foundation Notes:

- 1.Loads in 1000 lbs.
- 2.Crawl space ventilation shall not be less than 1/150th of the crawl space horizontal area.
- 3.This is a suggested plan only. Foundations to be designed by a professional engineer per local soil and climate conditions.
- 4.Provide access to crawl space, Minimum 22" x 24".
- 5.Minimum footing depth 3'-6"; or as required by local conditions.

Field Notes:

- 1.All foundation work shown on this drawing to be provided and installed on site per dealer under contractual agreement.

1	revised frame to perimeter type (sheets S2, F1, &F2) lrs	3-20-12	THIS DRAWING AND ALL INFORMATION CONTAINED HEREON IS THE PROPERTY OF WHITLEY MFG. CO. INC., AND IS NOT TO BE REPRODUCED WITHOUT THE EXPRESS PERMISSION OF WHITLEY MFG. CO., INC.		201 WEST FIRST STREET P.O. BOX 498 SOUTH WHITLEY, IN 46787 PHONE: 260.723.5131 FAX: 260.723.6949 www.whitleyman.com	Drawn By: lrs-sub	Foundation Notes & Details MODEL #6910 64'X24' (2) 60'-0"X11'-9" MODULES	Serial No.	Date
			WHITLEY MFG. CO. INC., ASSUMES NO RESPONSIBILITY FOR UNAUTHORIZED USE OF THIS DRAWING.		2755 FORT WAYNE ROAD P.O. BOX 505 ROCHESTER, IN 46975 PHONE: 574.223.4934 FAX: 574.223.8779 www.whitleyman.com	Checked By: PG		Quote No.	Scale:
						Rev: 1		Model No.	Page No.
NO.	REVISION	DATE						Job No.	F2

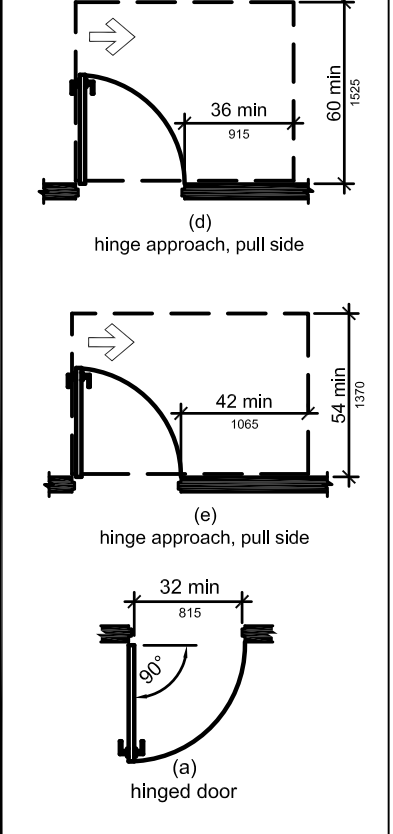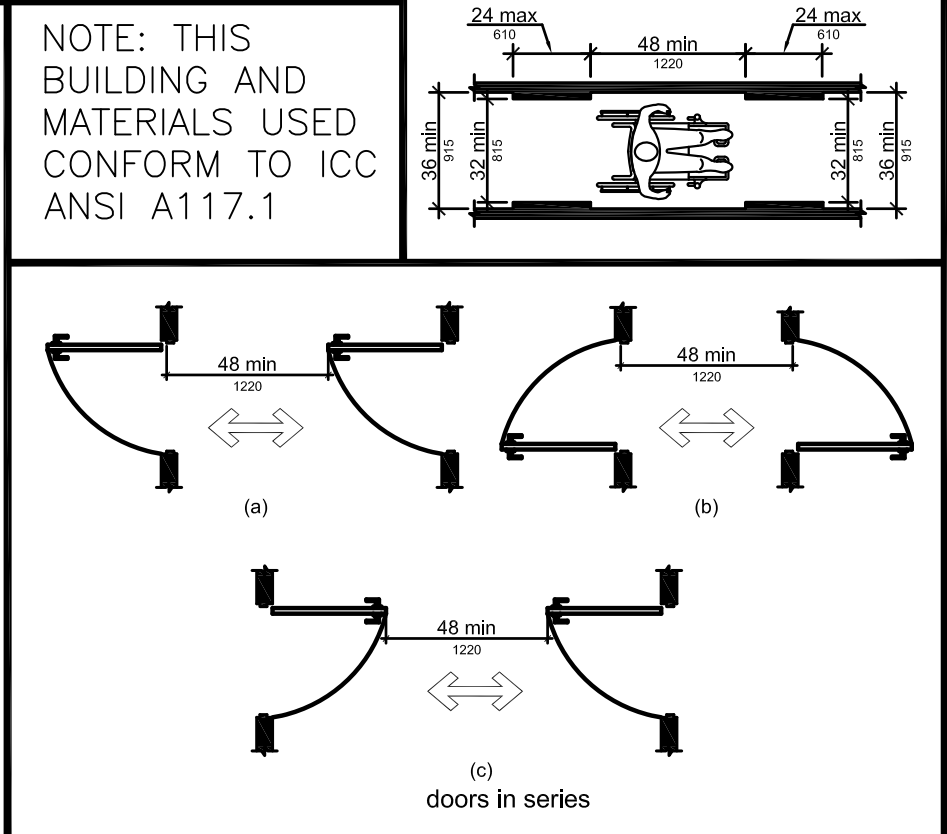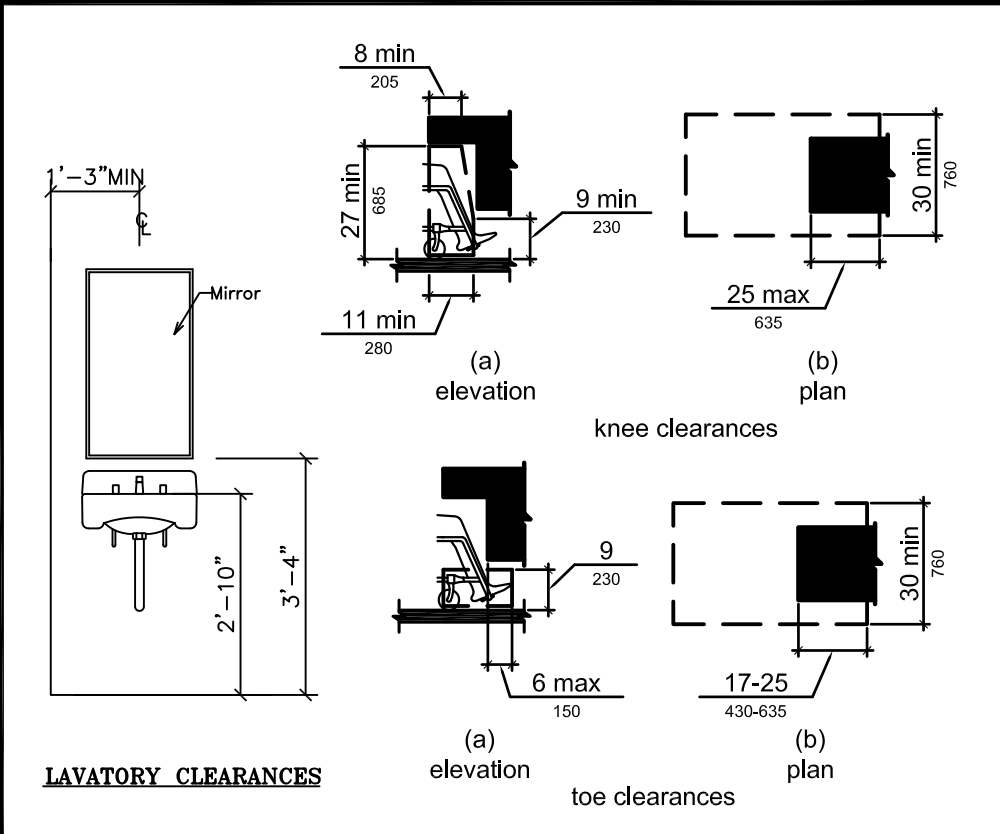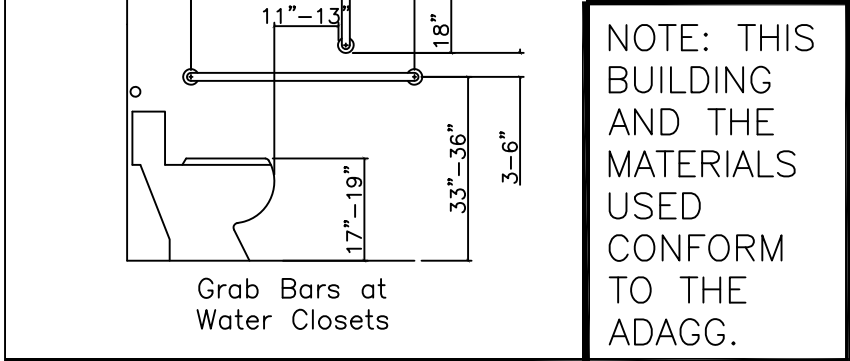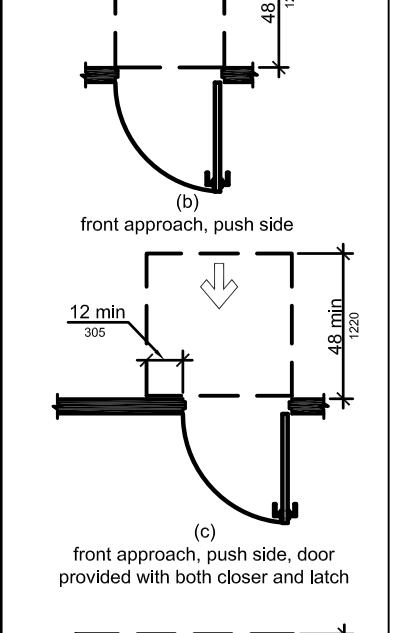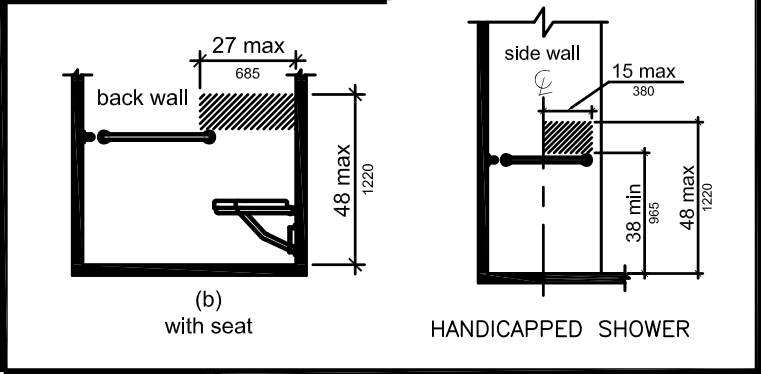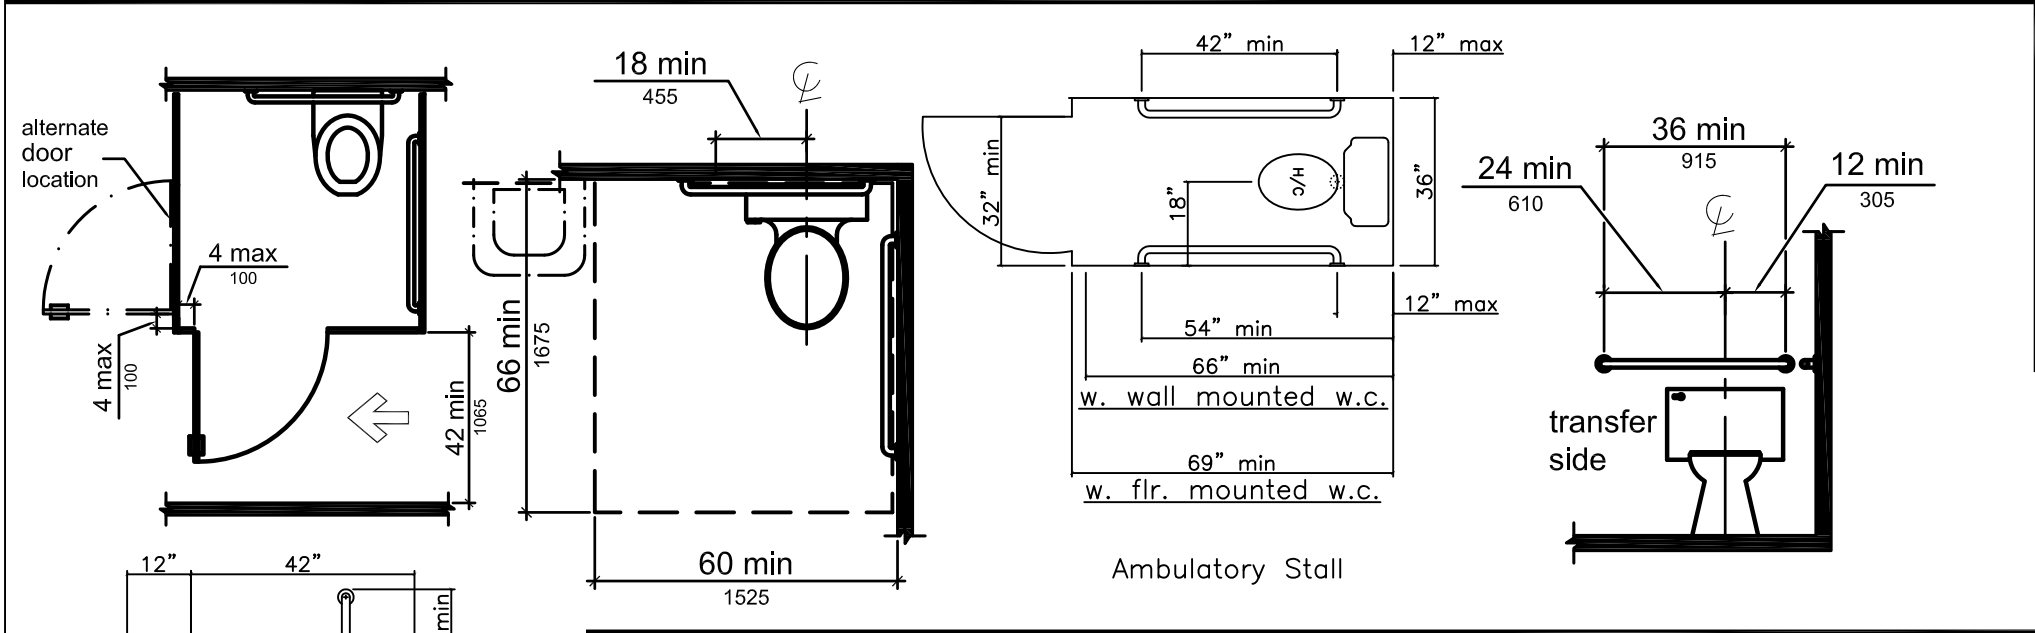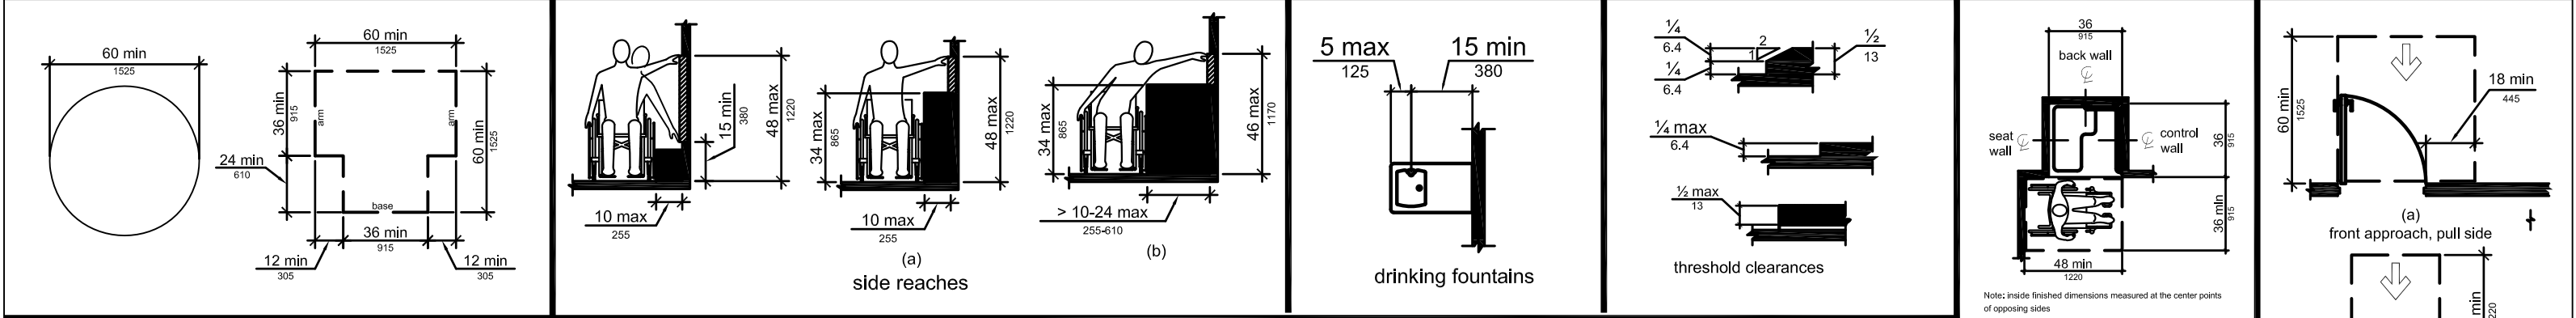

NO.	REVISION	DATE

THIS DRAWING AND ALL INFORMATION CONTAINED HEREON IS THE PROPERTY OF WHITLEY MFG. CO. INC., AND IS NOT TO BE REPRODUCED WITHOUT THE EXPRESS PERMISSION OF WHITLEY MFG. CO., INC.

WHITLEY MFG. CO. INC., ASSUMES NO RESPONSIBILITY FOR UNAUTHORIZED USE OF THIS DRAWING.



WHITLEY MANUFACTURING

201 WEST FIRST STREET
SOUTH WHITLEY, IN 46787
PHONE: 260.723.5131
FAX: 260.723.6949
www.whitleyman.com

2756 FORT WAYNE ROAD
P.O. BOX 505
ROCHESTER, IN 46975
PHONE: 574.223.4934
FAX: 574.223.8779
www.whitleyman.com

Drawn By:
SJH

Checked By:
sjh

Rev:

HANDICAPPED DETAILS

MODEL # 6766a

68' x 24' (64'-0" x 11'-9" MODULES)

Serial No.	Date
Serial #	4-30-07
Quote No.	Scale:
NONE	
Model No.	Page No.
Job No.	HC1

