




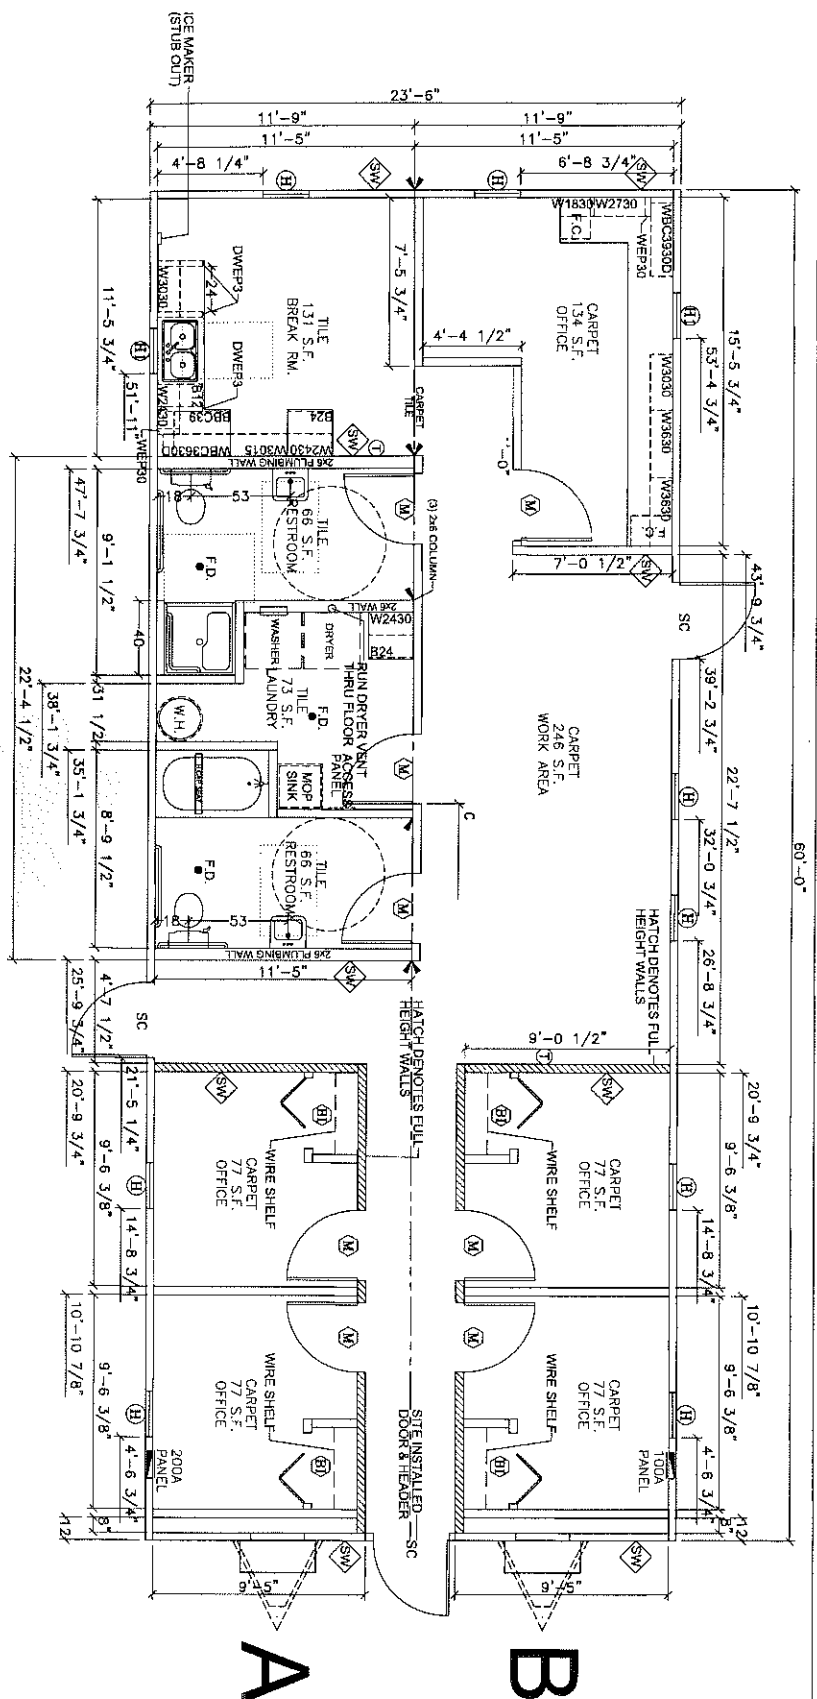


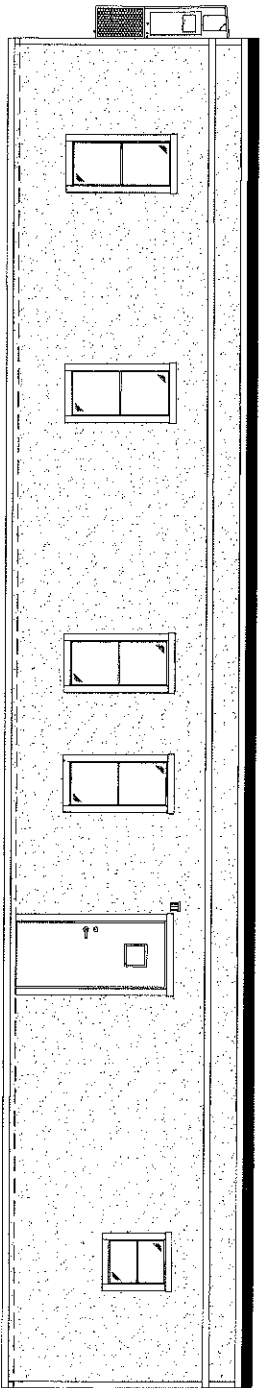


CURB SIDE

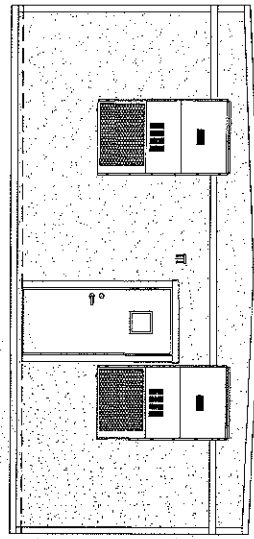

FRONT END

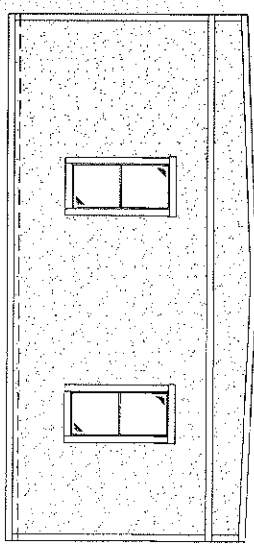


REAR END

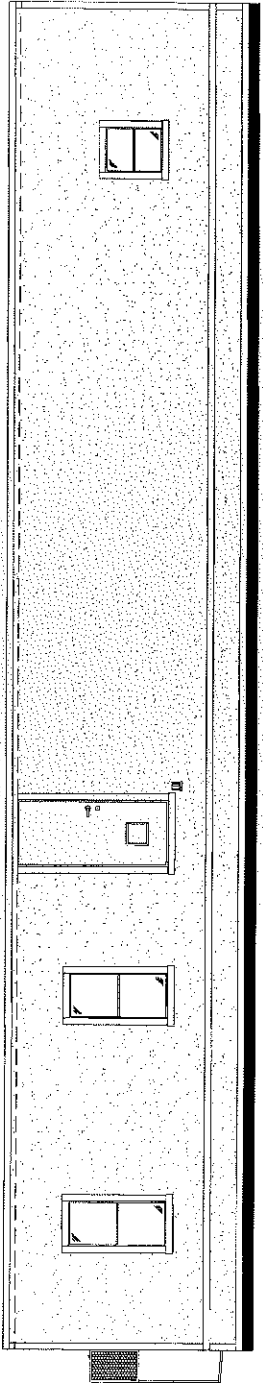


STREET SIDE

LTR	REVISION	BY	DATE	DRAWN BY	PROJECT	TITLE	DWG. NO.	SHEET
						EXTERIOR ELEVATION	V2484-3	A-4
					SCALE: 3/16"=1'-0"			
					DATE:			

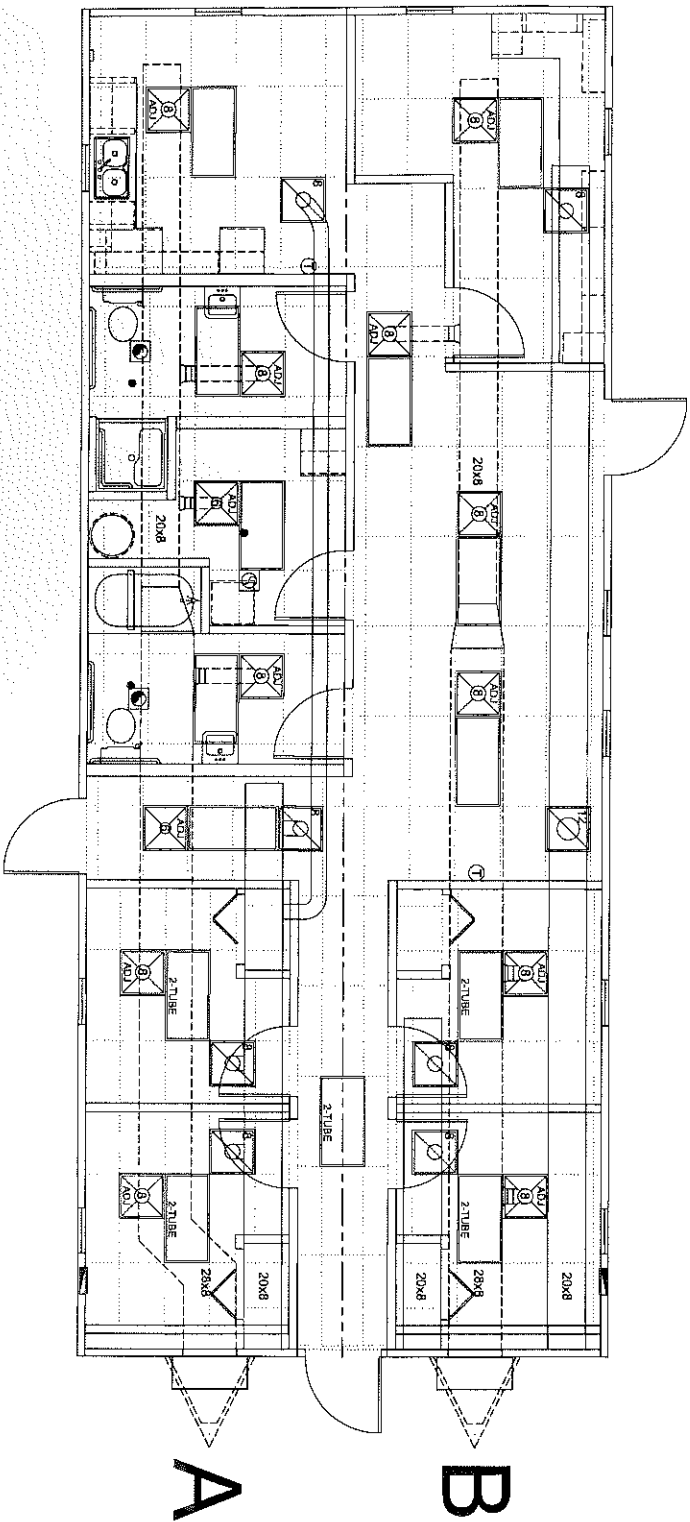

SYMBOL LEGEND

LTR	REVISION	BY	DATE	DRAWN BY:	PROJECT:	TITLE:
				DATE:	SCALE:	DWG. NO.
					3/16"=1'-0"	V2464-3

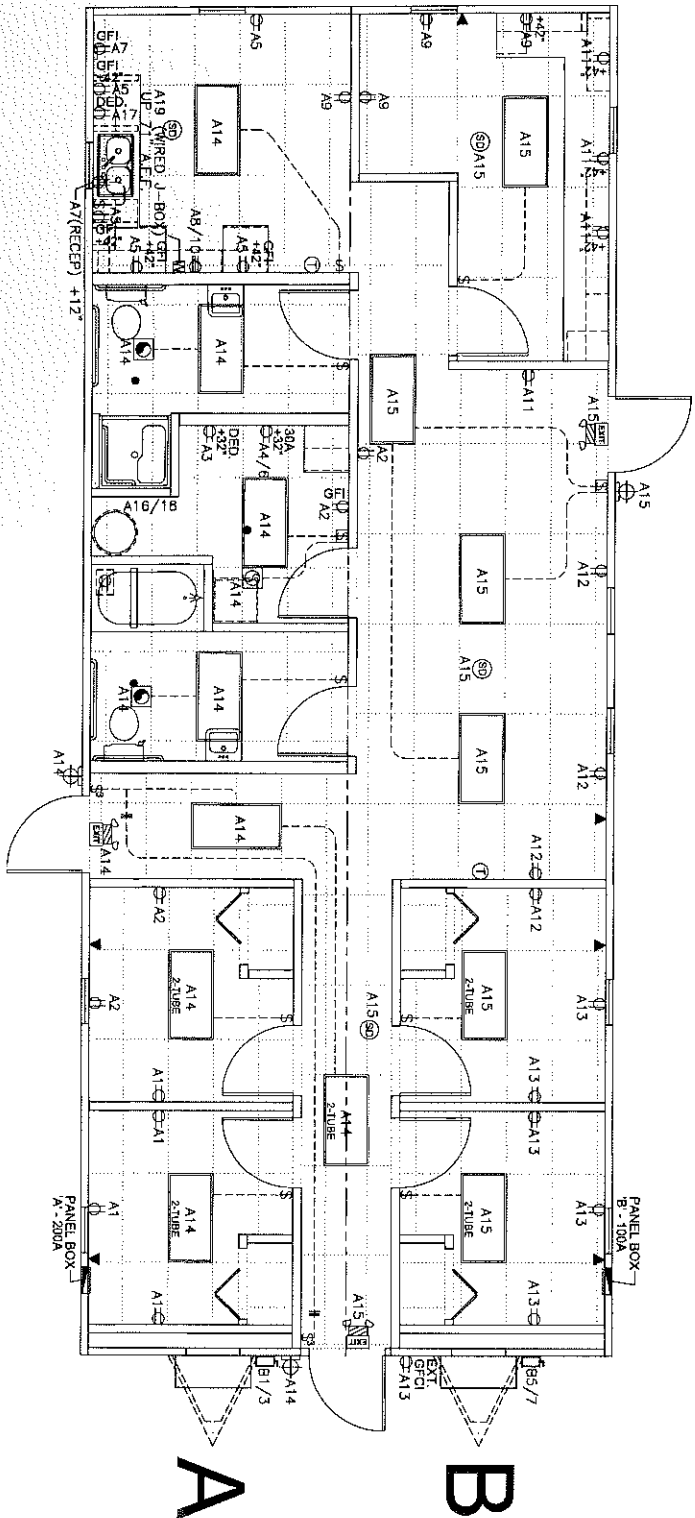

SYMBOL LEGEND

3" x 1/2" x 1/2" TUBE TRIGGER W. DISCONNECT (22 WATTS)	ROOF EXHAUST FAN ONLY	180CFM EXHAUST FAN ONLY			
EXT. PORCH LIGHT W/ PHOTO CELL (13 WATTS)	PHONE / DATA JACK SUB-IN LCTN				
120V DOUBLE TOGGLE SWITCH	120V SINGLE TOGGLE SWITCH				
120V DUPLEX RECEPTACLE	240V RANGE RECEPTACLE				
200 AMP LOAD CENTER	EXT. DISCONNECT				
THERMOSTAT LOCATION	SURFACE MTD. SMOKE DETECTOR (D/C)				
EMER/EXIT W/ BATT. BACKUP					
REVISION	BY	DATE	PROJECT	TITLE	DWG. NO.
SCALE	DATE	SCALE	PROJECT	TITLE	DWG. NO.
SCALE	DATE	SCALE	PROJECT	TITLE	DWG. NO.



- | | | | |
|----------------------------|-----|------------------|----------|
| TITLE: BLOCKING / TIE DOWN | | SHEET: S-2 | |
| DWG. NO. V2464-3 | | DATE: 3/16-17-0* | |
| PROJECT: | | SCALE: | |
| DATE: | BY: | DATE: | PROJECT: |
| REVISION | | DATE | |
| LIR | | DATE | |